


DUNDEE CIVIC COMMUNITY CENTER

BUILDING ADDITION & RENOVATION

165 VAN NEST STREET
DUNDEE, MICHIGAN 48131
CITY OF DUNDEE, MONROE CO

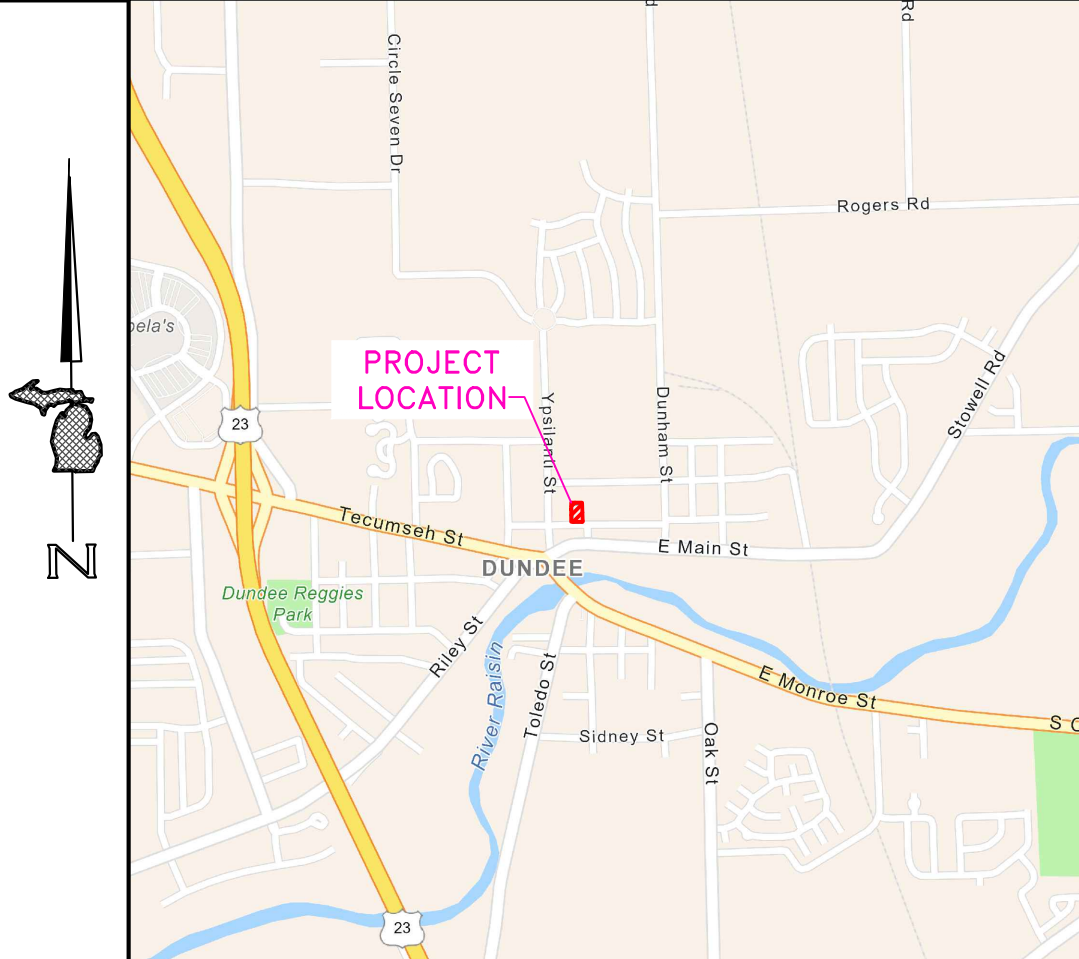

SITE LOCATION NTS

DAVID
ARTHUR
CONSULTANTS, INC.

PHONE: (734) 825-3000

FOR BID
PURPOSES
ONLY

NOT FOR
INSTRUCTION OR APPROVAL

SHEET INDEX

T1.00	TITLE PAGE
C1.01	STIE IMPROVEMENTS
LS1.00	LIFE SAFETY & CODE
D1.00	DEMOLITION PLAN
A1.00	FLOOR PLAN
A2.00	NORTH & SOUTH ELEVATIONS
A2.01	EAST & WEST ELEVATIONS
A3.00	BUILDING SECTIONS & DETAILS
A3.01	(OMITTED)
A3.02	(OMITTED)
A4.00	REFLECTED CEILING PLAN & KITCHEN DETAIL
A4.01	INTERIOR ELEVATIONS
A4.02	FINISH, DOOR & WINDOW SCHEDULES
S1.00	STRUCTURAL NOTES
S2.00	FOUNDATION PLAN & DETAILS
S3.00	ROOF FRAMING PLAN & DETAILS
S3.01	TYPICAL TRUSS BRACING
S4.01	DETAILS
P1.00	PLUMBING NOTES
P1.01	PLUMBING SCHEDULE & DETAILS
P2.00	PLUMBING PLAN
M1.00	MECHANICAL NOTES & SCHEDULES
M2.00	MECHANICAL PLAN
E1.00	ELECTRICAL NOTES & DETAILS
E2.00	LIGHTING PLAN
E3.00	POWER PLAN
E4.00	SITE ELECTRICAL & DETAILS

GRAPHIC SYMBOLS

DOOR NO. 

WINDOW NO. 

ROOM NAME _____

ROOM NUMBER _____

BUILDING SECTION
SHEET NUMBER 

DETAIL SECTION
SHEET NUMBER 

NORTH ARROW 

DETAIL
SHEET NUMBER 

INTERIOR ELEVATION
SHEET NUMBER 

APPENDUM 


CHANGE ORDER 

ABBREVIATIONS

AB	ANCHOR BOLT	CMI	CONCRETE MASONRY UNIT	F.D.	FLOOR DRAIN	LAV.	LAVATORY	SPEC	SPECIFICATIONS
ACI	AMERICAN CONCRETE INSTITUTE	C.O.	CLEAN OUT	FIN	FINISH	LP	LOW POINT	S.S.	SERVICE SINK
ACT	ACOUSTICAL CEILING TILE	CONC.	CONCRETE	FL	FLOOR	LRFD	LOAD AND RESISTANCE FACTOR DESIGN	STC	SOUND TRANSMISSION COEFFICIENT
ADA	AMERICANS WITH DISABILITIES ACT	CONT.	CONTINUOUS	FND	FOUNDATION	MANUF.	MANUFACTURER	STD	STANDARD
A.F.F.	ABOVE FINISH FLOOR	CW	COLD WATER	FT	FOOT	MAX.	MAXIMUM	STL	STEEL
A.F.G.	ABOVE FINISH GRADE	D	DRAIN	FTG	FOOTING	MECH	MECHANICAL	T&B	TOP & BOTTOM
A.H.J.	AUTHORITY HAVING JURISDICTION	DBL	DOUBLE	FUR.	FURNACE	MIN.	MINIMUM	T&G	TONGUE & GROOVE
A.I.A.	AMERICAN INSTITUTE OF ARCHITECTS	DCW	DOMESTIC COLD WATER	G	GAS	M.O.	MASONRY OPENING	TYP.	TYPICAL
AISC	AMERICAN INSTITUTE OF STEEL CONSTRUCTION	DEM.O.	DEMOLITION	GA	GAUGE	MTL	METAL	U.G.	UNDER GROUND
AISI	AMERICAN IRON AND STEEL INSTITUTE	DH	DOMESTIC HOT WATER	GALV	GALVANIZED	N.I.C.	NOT IN CONTRACT	U.N.O.	UNLESS NOTED OTHERWISE
ALUM.	ALUMINUM	DIA	DIAMETER	GC	GENERAL CONTRACTOR	NOM.	NOMINAL	V	VENT
ANOD.	ANODIZED	DN	DOWN	HM	HOLLOW METAL	NTS	NOT TO SCALE	VIF	VERIFY-IN-FIELD
ASD	ALTERNATE STRESS DESIGN	DWG	DRAWING	HOR	HORIZONTAL	O.C.	ON CENTER	VTR	VENT THRU ROOF
ASTM	AMERICAN SOCIETY FOR TESTING AND MATERIALS	EA.	EACH	HP	HIGH POINT	OPP	OPPOSITE	WC	WATER CLOSET
AWS	AMERICAN WELDING SOCIETY	EC	ELECTRICAL CONTRACTOR	HR	HOUR	OH	OVERHEAD	WD	WOOD
BF	BARRIER FREE	ECO	EXTERIOR CLEANOUT	HSS	HIGH STRENGTH STEEL	PSF	POUNDS PER SQUARE FOOT	WH	WATER HEATER
B.F.F.	BELOW FINISH FLOOR	ELEC.	ELECTRICAL	HT	HEIGHT	PSI	POUNDS PER SQUARE INCH	WP	WEATHER PROOF
B.F.G.	BELOW FINISH GRADE	ELEV.	ELEVATION	HVAC	HEATING, VENTILATING, AIR CONDITIONING	PVC	POLY/VINYL CHLORIDE	WWF	WELDED WIRE FABRIC
BOT.	BOTTOM	EJ	EXPANSION JOINT	HW	HOT WATER		RADIUS		
BRG	BEARING	EQ	EQUAL	INT	INTERIOR	RM	ROOM		
CJ	CONTROL JOINT	EXIST.	EXISTING	INV.	INVERT	SAN.	SANITARY		
CLG	CEILING	EXT.	EXTERIOR	K	KIP	SIM	SIMILAR		

OVERALL SITE PLAN

SCALE: 1" = 20'-0"

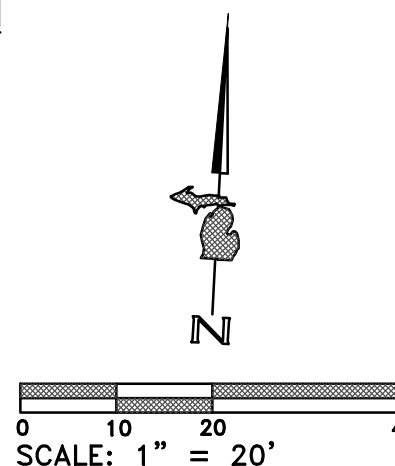

NOTE: DO NOT SCALE DRAWING, USE PRINTED DIMENSIONS ONLY. IF DRAWING IS REPRODUCED IN A SIZE OTHER THAN 24" x 36", SCALE MAY DIFFER. THIS DRAWING SHALL NOT BE DUPLICATED, MODIFIED, TRANSFERRED OR ISSUED WITHOUT THE WRITTEN CONSENT OF DAVID ARTHUR CONSULTANTS, INC. - COPYRIGHT 2025

**DUNDEE CIVIC
COMMUNITY CENTER**
165 VAN NEST STREET
DUNDEE, MICHIGAN 48131
VILLAGE OF DUNDEE, MONROE COUNTY

TITLE PAGE

DEVELOPER/OWNER:
VILLAGE OF DUNDEE

MICHAEL HOFFMEISTER, VILLAGE MANAGER
350 WEST MONROE ST.
DUNDEE, MI 48131
(734) 529-3430

DUNDEE

ISSUE			
ITEM	COMMENT DATE	DATE ISSUED	BY
FOR BID ONLY		11/7/73S	KI
ADDENDUM No.2		12/16/73S	KI
DRAWN BY ETH/KI		REVIEWED BY ARJ	

SCALE* AS NOTED

PLOT DATE	12/10/25
-----------	----------

JOB NO.	306001
---------	--------

SHEET NO.

T1.00

1. ALL WORK TO BE IN ACCORDANCE WITH ALL CURRENT CODES IN AFFECT AN IN ACCORDANCE WITH AGENCIES HAVING JURISDICTION.
2. THE CONTRACTOR SHALL NOTIFY THE ARCHITECT/ENGINEER IMMEDIATELY IF ANY DISCREPANCIES ARE FOUND WITHIN THESE PLANS OR WITH CURRENT SITE CONDITIONS.
3. THE CONTRACTOR SHALL BE RESPONSIBLE FOR ANY AND ALL SITE SAFETY MEASURES AND GUIDELINES.
4. THE ARCHITECT/ENGINEER IS NOT RESPONSIBLE FOR EXISTING CONDITIONS, CONDITIONS DURING DEMOLITION OR ANY OTHER PART OF THE PROJECT.
5. PEDESTRIANS, PUBLIC AND ANY OTHER PERSONS NEAR THE CONSTRUCTION SHALL BE PROTECTED FROM THE CONSTRUCTION AREA THROUGH USE OF CONSTRUCTION BARRIERS. BARRIERS AND OTHER PROTECTION MEASURES SHALL BE PROVIDED AND INSTALLED IN ACCORDANCE WITH MBC AND IN ACCORDANCE WITH ALL GOVERNING AGENCY REQUIREMENTS. THE EXACT LOCATION OF THE PROTECTION FENCING/MEASURES TO BE PLACED AT THE EDGE OF CONSTRUCTION AND ADJUSTED AS CONSTRUCTION REQUIRES.
6. PORTABLE FIRE EXTINGUISHER(S), SURFACE MOUNTED MIN. 5# ABC TYPE, SHALL BE PROVIDED ON SITE DURING DEMOLITION & CONSTRUCTION IN ACCORDANCE WITH THE INTERNATIONAL FIRE CODE SECTION 3315.1. MINIMUM OF ONE TO BE PROVIDED AT EACH STAIRWAY ON EACH FLOOR, IN STORAGE AND CONSTRUCTION SHEDS, ANY SPECIAL HAZARD AREAS. EXACT LOCATION AND QUANTITY SHALL BE COORDINATED WITH THE BUILDING OFFICIAL PRIOR AND DURING DEMOLITION AND CONSTRUCTION.
7. CONTRACTOR TO BE RESPONSIBLE FOR PROTECTING REMAINING SURFACES FROM PORTIONS TO BE DEMOLISHED. IT IS THE CONTRACTORS RESPONSIBILITY TO REPAIR ANY ADDITIONAL DEMOLITION DONE BEYOND WHAT IS REQUIRED AND TO MATCH THE EXISTING CONDITIONS.
8. WHERE COMPONENTS ARE REMOVED, ALL RESIDUAL GLUE, ADHESIVES, FASTENERS, ETC. TO BE REMOVED WITH MAJOR COMPONENTS.
9. CONTRACTOR IS RESPONSIBLE FOR PROVIDING ALL DEMOLITION ENGINEERING, INCLUDING TEMPORARY SUPPORTS/SHORING, AS REQUIRED FOR SITE AND PROJECT CONDITIONS.
10. REMOVE AND DISPOSE OF ALL MATERIALS LEGALLY OFF-SITE.

25. REMOVAL OF ANY WALL PENETRATIONS TO INCLUDE REPAIR AND FILLING OF EXISTING WALL TO MATCH ADJACENT MATERIALS AND FINISH. ALL PENETRATIONS IN EXTERIOR WALLS TO ALSO ENSURE FULL WATER TIGHT FINISH.

- (A) REMOVE EXISTING WINDOW, CONCRETE SILL, FRAME AND ACCESSORIES TO MASONRY OPENING
- (B) SAWCUT AND REMOVE EXISTING MASONRY WALL TO NOTED NEW OPENING DIMENSIONS
- (C) REMOVE EXISTING STUD WALL TO DIMENSIONS & CONFIGURATION NOTED ON PROPOSED FLOOR PLAN
- (D) REMOVE EXISTING DOOR, FRAME AND ACCESSORIES TO MASONRY OPENING
- (E) REMOVE EXISTING WALL TO NEW OPENING DIMENSION
- (F) REMOVE EXISTING STUD WALL
- (G) REMOVE EXISTING STUD WALL TO ROOF
- (H) REMOVE EXISTING BRICK VENER
- (I) REMOVE EXISTING CONCRETE SIDEWALK
- (J) REMOVE EXISTING ROOFING TO ROOF DECKING
- (K) REMOVE EXISTING FASCIA, SOFFIT, GUTTERS
- (L) REMOVE EXISTING GAS METER PIPING & SERVICE TO OUTSIDE PROPOSED ADDITION. CAP AND ABANDON EXISTING SERVICE LINE IN ACCORDANCE WITH UTILITY REQUIREMENTS.
- (M) REMOVE EXISTING ELECTRIC METER AND SERVICE
- (N) REMOVE EXISTING MILLWORK
- (O) REMOVE EXISTING EXHAUST DUCT THROUGH ROOF STACK
- (P) REMOVE EXISTING PVC VENT
- (Q) REMOVE EXISTING EXTERIOR LIGHT FIXTURE, REPAIR RESULTING HOLE(S) WITH SIMILAR WALL MATERIAL
- (R) REMOVE EXISTING WINDOW IN GABLE WALL, FILL-IN EXISTING OPENING WITH SIMILAR WALL MATERIAL
- (S) REMOVE EXISTING WOOD FRAMED GABLE WALL, WINDOW. REINSTALL NEW FRAMED WALL ON EXISTING BLOCK WALL
- (T) REMOVE EXISTING PLANTER, TIMBERS & LANDSCAPING, & SOIL
- (U) CEILING/ATTIC: REMOVE ALL EXISTING CEILING LIGHTS, CONDUIT, WIRING, FIXTURES & DEVICES, EXIT SIGNS, CROWN MOULDING
- (V) REMOVE EXISTING FURNACE, DUCTWORK, ELECTRICAL CONNECTIONS, GAS PIPING
- (W) REMOVE EXISTING WATER SERVICE AND PIPING TO BELOW SLAB
- (X) REMOVE EXISTING PLUMBING FIXTURES, ACCESSORIES, DRAIN AND SUPPLY PIPING
- (Y) REMOVE EXISTING WOOD FRAMED STAIRS & STAIR ENCLOSURE
- (Z) REMOVE EXISTING COAT RACK
- (a) EXISTING MASONRY WALL TO HAVE BROKEN BLOCKS REMOVED AND REPLACED, CRACKED MORTAR JOINTS TO BE TUCK POINTED. REPLACE WITH SOLID BLOCK UNLESS REBAR IS PRESENT, FULL GROUT. NUMBER OF BLOCKS AND LENGTH OF TUCK POINTING LISTED
- (b) REMOVE EXISTING PLUMBING PIPING
- (d) REMOVE GYPSUM BOARD, BOTH SIDES OF WALL
- (e) REMOVE AND REPLACE FOUNDATION BLOCKS, QUANTITY NOTED AT EACH LOCATION. REPLACE WITH SOLID BLOCK UNLESS REBAR IS PRESENT, FULL GROUT.
- (f) REMOVE EXISTING CONCRETE SLAB AT DOOR AND 1 BLOCK EACH SIDE OF OPENING. REPLACE WITH CONCRETE WHERE DOOR TO REMAIN OR WITH MASONRY WHERE DOOR IS TO BE REMOVED.
- (g) REMOVE EXISTING INSULATION AND DEBRIS IN FLOOR OF ATTIC
- (h) REMOVE EXISTING BLOCK TO 8" BELOW FLOOR LEVEL, REPLACE WITH CONCRETE, FLUSH WITH FLOORING, AS NOTED
- (i) REMOVE EXISTING OPENING HEADER AND BLOCK TO PROPOSED ROUGH OPENING



NOT FOR
CONSTRUCTION OR APPROVAL

DEMOLITION PLAN

[illegible]

JOB NO. 306001

SHEET NO.

D1.00



A		EXTERIOR WALL: 5/8" GYPSUM BOARD INTERIOR, 7/16" WOOD STUDS @ 16" O.C., MIN. R-21 INSULATION, 7/16" OSB SHEATHING, 1" POLYISO INSULATION (R-6.5), TYVEK MOISTURE BARRIER, DRAIN SCREEN BEHIND CULTURED STONE, SIDING AS NOTED ON ELEVATIONS TOTAL WIDTH: 6 5/8"
B		INTERIOR WALL: 2x6 WOOD STUDS @ 16" O.C., SOUND INSULATION, 5/8" GYPSUM BOARD BOTH SIDES, FINISH PER OWNER OR AS NOTED (MOISTURE RESISTANT GYPSUM ADJACENT TO PLUMBING FIXTURES). TOTAL WIDTH: 6 3/4"
C		INTERIOR WALL: 2x4 WOOD STUDS @ 16" O.C., SOUND INSULATION, 5/8" GYPSUM BOARD BOTH SIDES, FINISH PER OWNER OR AS NOTED (MOISTURE RESISTANT GYPSUM ADJACENT TO PLUMBING FIXTURES). TOTAL WIDTH: 4 3/4"
D		EXTERIOR WALL: 5/8" GYPSUM BOARD INTERIOR, 3/4" HAT CHANNELS & 16" O.C., 3/4" RIGID INSULATION, EXISTING CONCRETE MASONRY UNITS (ASSUME 8" NOMINAL) 2.5" ZIP SYSTEM INSULATED SHEATHING, (2" RIGID INSULATION WITH 7/16" OSB), TYVEK MOISTURE BARRIER, SIDING AS NOTED ON ELEVATIONS TOTAL WIDTH: 11 1/2"
E		INTERIOR WALL: 5/8" GYPSUM BOARD, 3/4" HAT CHANNELS & 16" O.C., EXISTING CONCRETE MASONRY UNITS (ASSUME 8" NOMINAL), 3/4" HAT CHANNELS & 16" O.C., 5/8" GYPSUM BOARD TOTAL WIDTH: 10 3/4"
EXISTING WALL TO REMAIN		
IN-FILL WALL - MATCH EXISTING MATERIALS AND OVERALL WIDTH		

1. ALL CONSTRUCTION TO BE IN ACCORDANCE WITH THE CODES AS NOTED IN THE DESIGN CRITERIA.
2. ALL DIMENSIONS ARE TO FINISH FACE OF WALLS.
3. DOOR/HALL SIGNAGE: (WS)
 - A. BRAILLE SIGNS TO BE OF INDUSTRY STANDARD SIZE, GRAPHICS TO BE INTERNATIONAL SYMBOLS FOR INDICATED USE, LETTERING TO BE 5/8" HIGH RAISED 1/32" W/NO. 2 BRAILLE CODING, FRAMES TO BE 1/8" ALUMINUM SATIN FINISH W/ 3/8" RADIUS AT CORNERS, NON-MAGNETIC BACKING
 - B. ACCESSIBLE ENTRY OR EXIT SIGNS TO BE STANDARD DOOR/WINDOW STICKER WHERE NOT ALL ENTRANCES ARE ADA ACCESSIBLE. ACCESSIBLE ENTRY SIGN TO BE SETON #55839 (OR ACCEPTABLE ALTERNATE) VINYL STICKER, 4"x4" SQUARE, WHITE & BLUE.
 - C. WHERE THERE IS NO SIGNING ABOVE, TOILET ROOM SIGNS TO BE SETON #84578/84579 (OR ACCEPTABLE ALTERNATE)
- D. EMERGENCY NOTIFICATION SIGNS TO BE PROVIDED AS REQUIRED BY REGULATORY AUTHORITIES HAVING JURISDICTION.
- E. SIGNS TO BE PROVIDED:
 1. MEN'S WS-1
 2. WOMEN'S WS-2
 3. HALL WS-3
 4. JANITORS CLOSET WS-4
 5. STORAGE WS-5 (x2)

- ALL WALLS TO BE RUN TIGHT TO ROOF DECK, OR STRUCTURE ABOVE, U.N.O.
5. FRAMING CONTRACTOR FOR INTERIOR WALLS SHALL BE RESPONSIBLE FOR INSTALLATION OF ALL WOOD BLOCKING FOR, BUT NOT LIMITED TO, CABINETRY, MILLWORK, COUNTERS AND SINKS, TUBS, SHELVE, AND ACCESSORIES. ADA COMPLIANCE. PLUMBING CONTRACTOR SHALL BE RESPONSIBLE TO COORDINATE WITH OTHER TRADES TO ENSURE ALL BLOCKING IS INSTALLED PRIOR TO INSTALLATION OF INSULATION AND GYPSUM BOARD.
6. ASBESTOS-FREE PRODUCT INSTALLATION NOTES:
 - A. IT IS HEREBY UNDERSTOOD AND AGREED THAT NO PRODUCT AND/OR MATERIAL CONTAINING CHRYSOLOTE, CROCIDOLITE, ACTINOLITE, CROCIDOLITE, TEMOLITE ASBESTOS, ANTHOPHOLITE ASBESTOS, ACTINOLITE ASBESTOS AND ANY COMBINATION OF THESE MATERIALS THAT HAVE BEEN CHEMICALLY TREATED AND/OR ALTERED SHALL BE INSTALLED OR INTRODUCED INTO THE WORK BY THE CONTRACTOR OR HIS EMPLOYEES, AGENTS, SUBCONTRACTORS OR OTHER INDIVIDUALS OR ENTITIES OVER WHOM THE CONTRACTOR HAS CONTROL. THE CONTRACTOR SHALL ALSO BE REQUIRED TO SIGN A CERTIFICATION STATEMENT ENSURING THAT ALL PRODUCTS OR MATERIALS INSTALLED OR INTRODUCED INTO THE WORK WILL BE ASBESTOS-FREE.
 - B. THE CONTRACTOR SHALL ALSO BE REQUIRED TO FURNISH CERTIFIED STATEMENTS FROM THE MANUFACTURERS OF SUPPLY MATERIALS TO VERIFY THE CONSTRUCTION VERIFYING THEIR PRODUCTS TO BE ASBESTOS-FREE IN ACCORDANCE WITH THE REQUIREMENTS OF SECTION 8.4.3.1.
 - C. THE CONTRACTOR MAY BE REQUIRED TO COMPLETE AND SUBMIT TO THE OWNER A CERTIFICATION EVIDENCING ASBESTOS-FREE PRODUCT INSTALLATION PRIOR TO ISSUANCE OF THE FINAL PAYMENT TO THE CONTRACTOR.
7. THE CONTRACTOR SHALL NOTIFY THE ARCHITECT/ENGINEER IMMEDIATELY IF ANY DISCREPANCIES ARE FOUND WITH THESE PLANS, WITH CURRENT SITE CONDITIONS, OR WITH ANY MANUFACTURER RECOMMENDED INSTALLATION DETAILS OR INFORMATION. CONSTRUCTION SHALL NOT PROCEED UNLESS A DETERMINATION IS GIVEN TO WHICH DIRECTION IS INTENDED. IF WHERE THE CONTRACTOR'S INTERESTS ARE IN CONFLICT WITH MANUFACTURER STANDARD SPECIFICATIONS, DETAILS OR INSTALLATION RECOMMENDATIONS, OR MAY AFFECT ANY WARRANTY OR GUARANTEE FROM THE MANUFACTURER, THE CONTRACTOR SHALL PROVIDE CHANGES TO THE ARCHITECT/ENGINEER FOR REVIEW AND APPROVAL. WORK SHALL NOT CONTINUE ON SUCH ITEMS UNTIL APPROVAL IS GIVEN BY THE ARCHITECT/ENGINEER.
8. THE CONTRACTOR SHALL BE SOLELY RESPONSIBLE FOR ALL SITE SAFETY AND MEANS AND METHODS THROUGHOUT THE PROJECT. PEDESTRIANS, PUBLIC AND ANY OTHER PERSONS NEAR THE CONSTRUCTION SHALL BE PROTECTED FROM THE CONSTRUCTION AREA THROUGH USE OF CONSTRUCTION BARRIERS, BARRIERS AND OTHER PROTECTION MEASURES SHALL BE PROVIDED AND INSTALLED IN ACCORDANCE WITH MBC SECTION 35. IF THE EXACT LOCATION OF THE PROJECT IS NOT SHOWN ON THE PLANS, THE CONTRACTOR SHALL PROVIDE DOCUMENTS, THE FENCE SHALL BE PLACED AT THE EDGE OF THE CONSTRUCTION AREA.
9. OPENINGS IN ANY FLOOR OR ROOF SHALL BE PROTECTED AROUND THE PERIMETER OF THE OPENING TO PREVENT ACCESS BY ANY PERSON IN THE AREA OF SUCH OPENING.
11. PORTABLE FIRE EXTINGUISHER(S), SURFACE MOUNTED, MIN. 5# ABC TYPE, SHALL BE PROVIDED ON EACH FLOOR DURING CONSTRUCTION. EXACT LOCATION SHALL BE COORDINATED WITH THE BUILDING OFFICIAL.
12. PAINT ANY GAS PIPING EXPOSED TO VIEW WITH RUSTOLEUM PRIMER AND TWO FINISH COATS WITH COLOR AS SELECTED BY OWNER.
13. ALL ELECTRICAL CONDUITS AND DEVICES EXPOSED TO VIEW, INTERIOR OR EXTERIOR, INCLUDING VENTS THROUGH THE ROOF, COLOR TO TYPICALLY MATCH ADJACENT SURFACE, AND TO BE APPROVED BY OWNER AND/OR ARCHITECT/ENGINEER PRIOR TO APPLICATION.
14. NO HAZARDOUS MATERIALS ARE TO BE STORED WITHIN OR AROUND THE BUILDING. PER THE OWNER, THERE WILL BE NO HIGH-PILED COMBUSTIBLE STORAGE (COMBUSTIBLE MATERIALS).
15. MASONRY UNITS TO BE SET IN A STANDARD RUNNING BOND PATTERN, 1500 PSI MIN. BLOCK STRENGTH. MORTAR TO BE TYPE M OR S.
16. DEFERRED SUBMITTAL TO INCLUDE:
 - TRUSS DESIGN DRAWINGS
 - THESE ITEMS WILL BE SUBMITTED TO THE BUILDING OFFICIAL AS SOON AS THEY ARE RECEIVED AND REVIEWED AND SIGNED BY THE DESIGN PROFESSIONAL IN RESPONSIBLE CHARGE.
 17. CONCRETE PAD LOCATION AND SIZE SHALL BE COORDINATED WITH EACH SPECIFIC TRADE. VERIFY ALL REQUIRED CLEARANCES AND ACCESS POINTS ARE PROVIDED. CONTRACTOR SETTING SHALL BE IN ACCORDANCE WITH THE CITY OF CHICAGO.
 18. IN ACCORDANCE WITH MBC CHAPTER 17, BELOW ARE THE REQUIRED SPECIAL INSPECTIONS AND TEST(S) REQUIRED FOR THIS PROJECT:
 - NONE
 19. DRAWING DIMENSIONS GOVERN OVER SCALE, IT IS THE RESPONSIBILITY OF THE CONTRACTOR TO CONFIRM ALL DIMENSIONS AND REPORT ANY DISCREPANCIES TO THE DESIGNER PRIOR TO ORDERING ANY MATERIALS OR BEGINNING CONSTRUCTION. EXTERIOR WALLS ARE DIMENSIONED TO THE EXTERIOR, INTERIOR WALLS DIMENSIONED TO THE CENTER OF THE WALL, AND OPENINGS DIMENSIONED TO THE CENTER OF THE OPENING.
 20. INSTALL RAINSCREEN, MTI GRAVITY CAVITY, OR EQUIVALENT, AT ALL STONE.
 21. SNOW BRACKES TO BE PROVIDED AT ALL METAL ROOF OVERHANGS OVER SIDEWALKS AND DOORS.

WALL NO.

DOOR NO.

WINDOW NO.

ROOM NAME
ROOM NUMBER ASSEMBLY HALL

BUILDING SECTION
SHEET NUMBER 101

INTERIOR ELEVATION
SHEET NUMBER

NOTE: DO NOT SCALE DRAWING, USE PRINTED DIMENSIONS ONLY. IF DRAWING IS REPRODUCED IN A SIZE OTHER THAN 24" x 36", SCALE MAY DIFFER. THIS DRAWING SHALL NOT BE DUPLICATED, MODIFIED, TRANSFERRED OR ISSUED WITHOUT THE WRITTEN CONSENT OF DAVID ARTHUR CONSULTANTS, INC. - COPYRIGHT 2025.

The diagram shows a large rectangle on the left, which is divided into several smaller rectangles and triangles on the right. The rectangles are colored blue and green, and the triangles are colored yellow. This illustrates the area formula for a trapezoid, which is the sum of the areas of these smaller shapes.

FOR BID
PURPOSES
ONLY

110 MAIN STREET, DUNDEE, MI 48131
PHONE: (734) 823-5080

NOT FOR CONSTRUCTION OR APPROVAL

DUNDEE CIVIC
COMMUNITY CENTER

165 VAN NEST STREET
DUNDEE, MICHIGAN 48131
VILLAGE OF DUNDEE, MONROE COUNTY

FLOOR PLAN

DEVELOPER/OWNER:

VILLAGE OF DUNDEE
MICHAEL HOFFMEISTER, VILLAGE MANAGER
350 WEST MONROE ST.
DUNDEE, MI 48131

 
 
[illegible]SCALE*  AS NOTED

PLOT DATE 12/10/25

306001

SHEET NO.

A1.00







FOR BID
PURPOSES
ONLY

NOT FOR
CONSTRUCTION OR APPROVAL


DEVELOPER/OWNER:
VILLAGE OF DUNDEE
MICHAEL HOFFMEISTER, VILLAGE MANAGER
3850 WEST MONROE ST.
DUNDEE, MI 48131
(734) 529-3430

ISSUE			
ITEM	COUNT	DWG.	BY
FOR BID ONLY ADDENDUM No.2		17/7/75	Rt
		12/10/25	KI
DRAWN BY ETH/KI			REVIEWED BY ARJ

SCALE*	AS NOTED
PLOT DATE	12/10/25
JOB NO.	306001
SHEET NO.	
A2.01	

  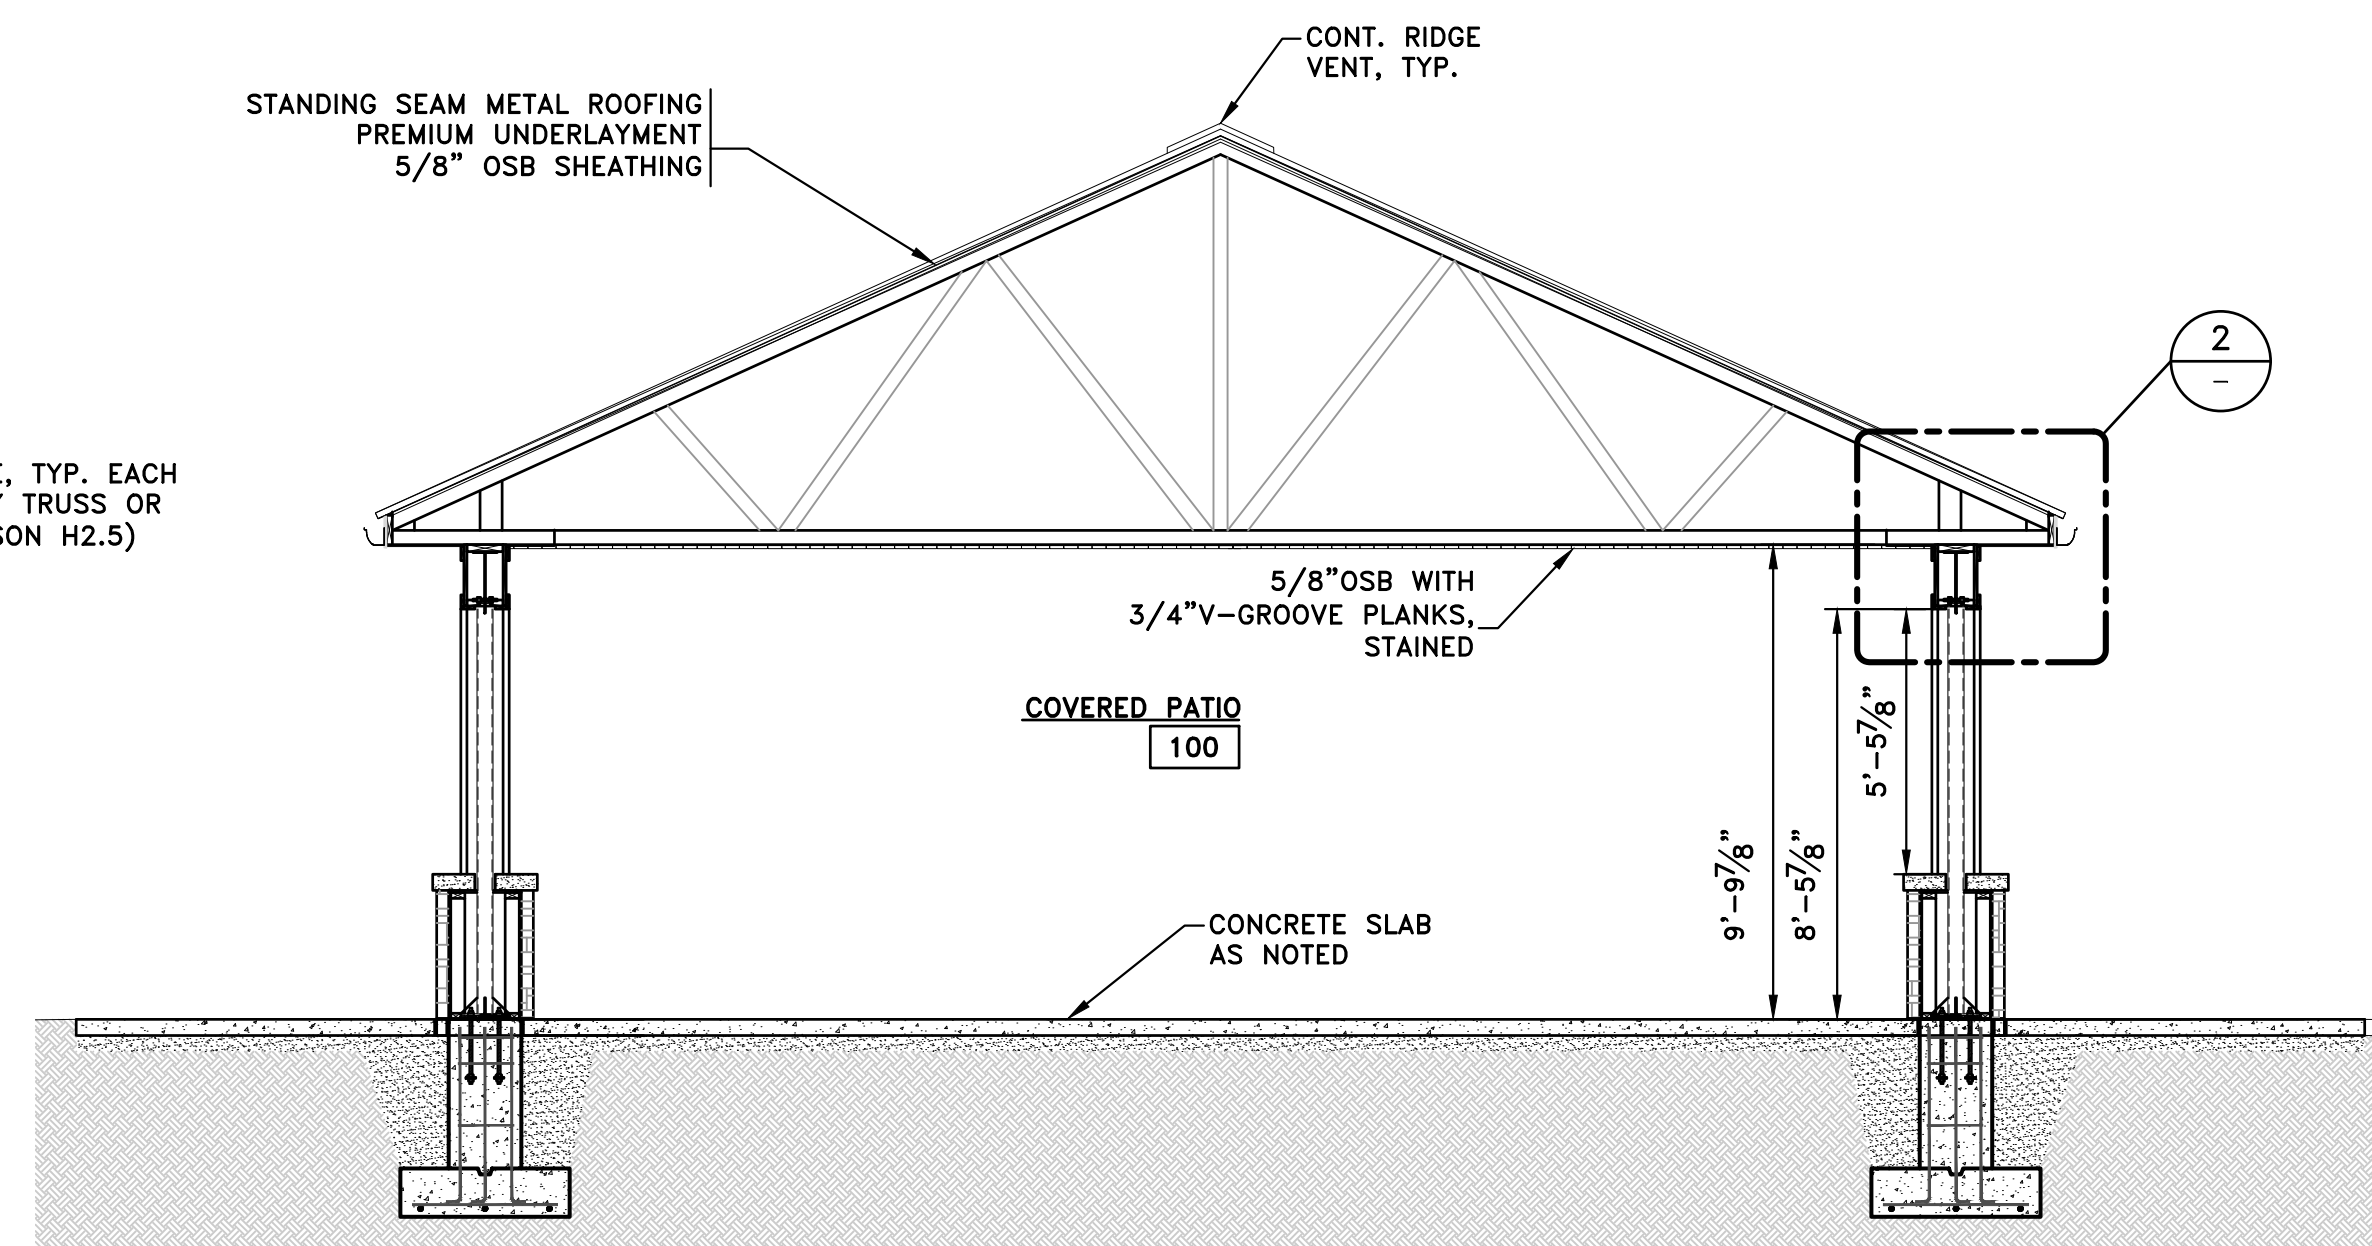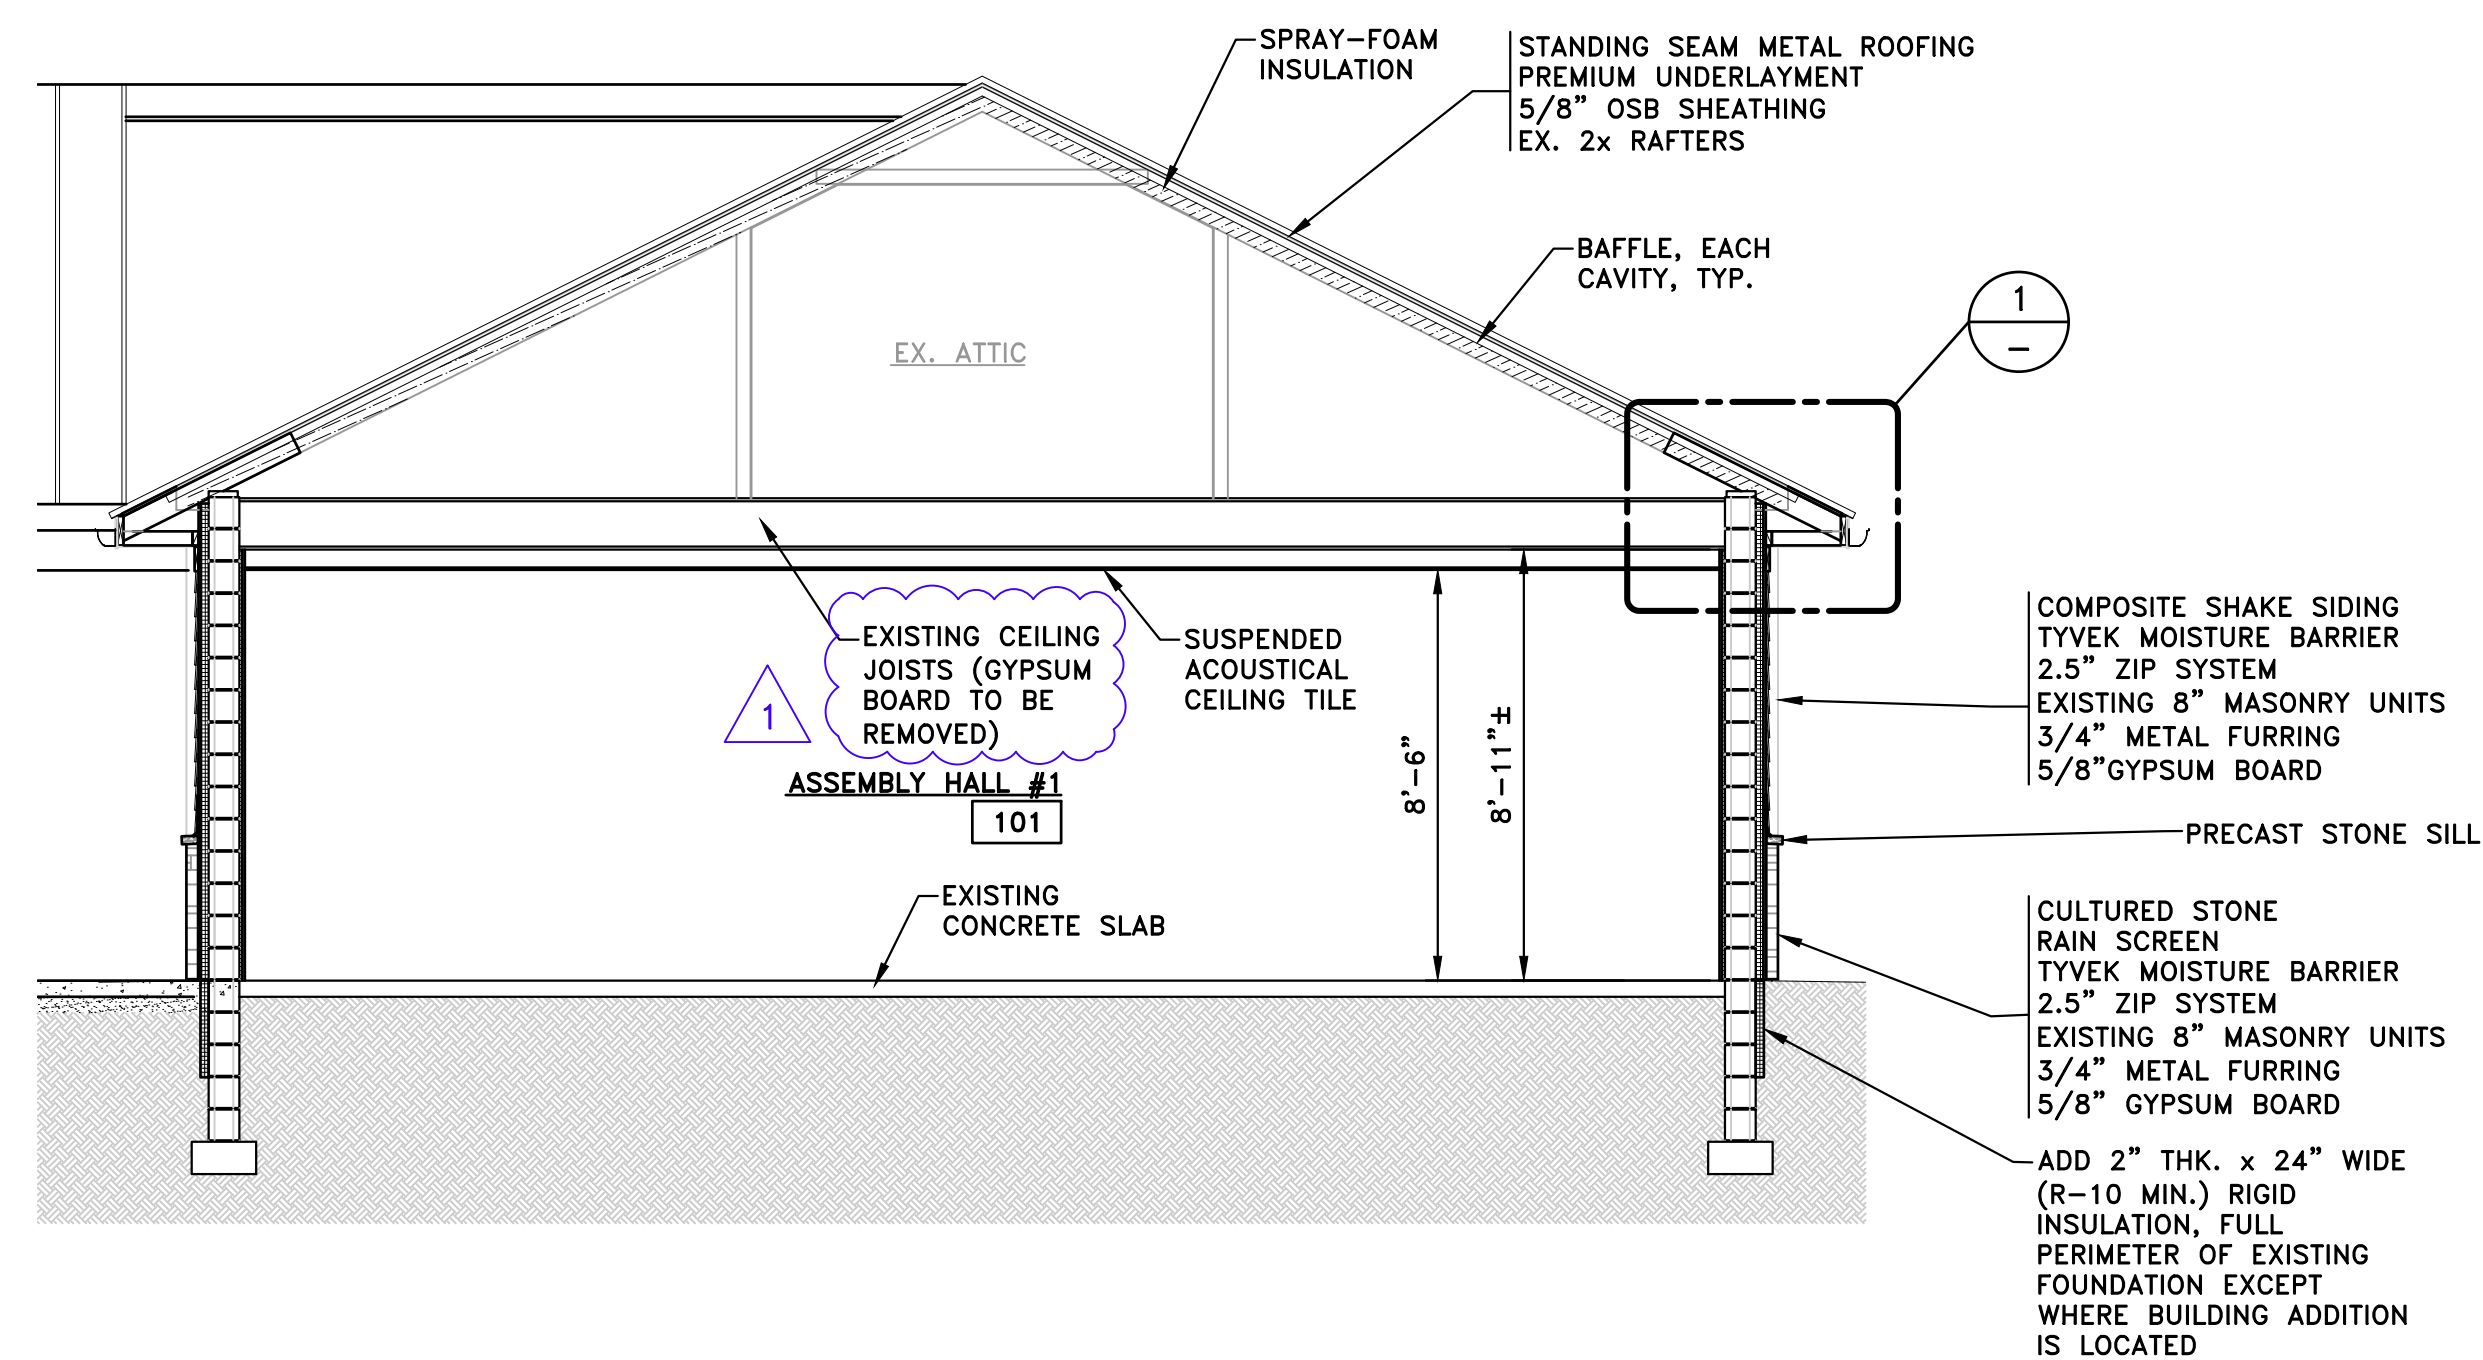

 NOTE: DO NOT SCALE DRAWING, USE PRINTED DIMENSIONS ONLY. IF DRAWING IS REPRODUCED IN A SIZE OTHER THAN 24" x 36", SCALE MAY DIFFER. THIS DRAWING SHALL NOT BE DUPLICATED, MODIFIED, TRANSFERRED OR ISSUED WITHOUT THE WRITTEN CONSENT OF DAVID ARTHUR CONSULTANTS, INC. - COPYRIGHT 2025.



SYMBOL	DESCRIPTION
	RECESSED CAN
	2x4 LED FIXTURE
	1x4 LED FIXTURE
	EXHAUST FAN
	HVAC SUPPLY REGISTERS
	HVAC RETURN GRILLES
	2x2 SUSPENDED ACOUSTICAL CEILING TILES

FOR BID
PURPOSES
ONLY

REFLECTIVE CEILING PLAN & KITCHEN DETAIL

[illegible]

SHEET NO.

A4.00



SCALE: 1/2" = 1'-0"



SCALE: 1/2" = 1'-0"

FOR BID
PURPOSES
ONLY

DUNDEE CIVIC
COMMUNITY CENTER
165 VAN NEST STREET
DUNDEE, MICHIGAN 48131
VILLAGE OF DUNDEE, MONROE COUNTY

INTERIOR ELEVATIONS

DEVELOPER/OWNER:

DEVELOPER/OWNER.
VILLAGE OF DUNDEE
MICHAEL HOFFMEISTER, VILLAGE MANAGER
350 WEST MONROE ST.
DUNDEE, MI 48131
(734) 529-3430

[illegible]

SCALE* AS NOTED

PLOT DATE	12/10/25
-----------	----------

JOB NO.	306001
---------	--------

SHEET NO.

A4.01

DOOR SCHEDULE - Dundee Civic Community Center

11/17/2025

OPENING NO.	GENERAL			RATING	Door				Frame				MISC.			
	LOCATION		THICKNESS		MATERIAL	Width	Height	ELEVATION	MATERIAL	FRAME WIDTH	HEAD HEIGHT	ELEVATION	HARDWARE SET	HEAD DETAIL ⁵	JAMB DETAIL ⁵	Remarks
	FROM	TO														
101A	101	Exterior	None	1 3/4"	Aluminum - Storefront	3'-0"	7'-0"	D1	Aluminum - Storefront	2"	2"	F1	1	H-1	J-1	
101B	101	Exterior	None	1 3/4"	Insulated Steel	3'-0"	7'-0"	D2	Hollow Metal, welded	2"	2"	F3	1	H-2	J-2	
101C	101	Exterior	None	1 3/4"	Insulated Steel	3'-0"	7'-0"	D2	Hollow Metal, Welded	2"	2"	F3	1	H-7	J-7	
101D	101	105	None	1 3/4"	Aluminum - Storefront	3'-0"	7'-0"	D1	Aluminum - Storefront	2"	2"	F4	2	H-9	J-9	
104	105	104	None	1 3/4"	Wood	3'-0"	7'-0"	D2	Hollow Metal, Welded	2"	2"	F3	5	H-7	J-7	
105	105	Exterior	None	1 3/4"	Aluminum - Storefront	6'-0"	7'-0"	D4	Aluminum - Storefront	2"	2"	F2	6	H-4	J-4	
106	105	106	None	1 3/4"	Wood	3'-0"	7'-0"	D2	Hollow Metal, Welded	2"	2"	F3	5	H-7	J-7	
107	101	107	None	1 3/4"	Wood	3'-0"	7'-0"	D2	Hollow Metal, welded	2"	2"	F3	3	H-8	J-8	
108	101	108	None	1 3/4"	Wood	6'-0"	7'-0"	D3	Hollow Metal, welded	2"	2"	F2	4	H-8	J-8	
109	101	109	None	N/A	N/A	N/A	N/A	N/A	Hollow Metal, welded	2"	2"	F3	N/A	H-2	J-2	

- NOTES:
- ALL DOOR HARDWARE TO BE ADA COMPLIANT
 - ALL DOOR HANDLES TO BE LEVER TYPE
 - ALL WOOD DOORS TO BE SOLID CORE
 - ALL DOOR HARWARED FINISHES TO BE BRUSHED OR SATIN CHROME (26D OR 32D)
 - SEE THIS SHEET FOR DETAILS

HARDWARE SETS


- SET #1
- 3 HINGES
 - 1 RIM EXIT DEVICE W/ EXTERIOR LEVER
 - 1 CLOSER
 - 1 WEATHER SEAL
 - 1 DOOR SWEEP
 - 1 ADA THRESHOLD
- SET #2
- 3 HINGES
 - 1 RIM EXIT DEVICE W/ EXTERIOR LEVER
 - 1 CLOSER
 - 1 WALL BUMPER
- SET #3
- 3 HINGES
 - 1 LOCK SET - STORAGE
 - 1 MOP PLATE
 - 1 KICK PLATE
- SET #4
- 6 HINGES
 - 1 LOCK SET - STORAGE
 - 2 MOP PLATE
 - 2 KICK PLATE
- SET #5
- 3 HINGES
 - PUSH/PULL HARDWARE
 - 1 CLOSERS
 - 2 KICK PLATES
- SET #6
- 6 HINGES
 - 2 FLUSH BOLTS
 - 1 DEAD LATCH/PADDLE
 - 1 CYLINDER
 - 2 C-PULLS
 - 2 DUMMY BARS
 - 2 CLOSERS
 - 2 DROP PLATES
 - 2 DOOR SWEEPS
 - 1 ADA THRESHOLD
 - 1 WEATHER STRIP

WINDOW SCHEDULE


SYM	INDIVIDUAL UNIT WIDTH**	INDIVIDUAL UNIT HEIGHT**	U VALUE (APPROX.)*	GLAZING	TYPE	HEAD DETAIL**	JAMB DETAIL***	SILL DETAIL***	MATERIAL	REMARKS/MODEL#
A	5'-11 7/8"	4'-0"	0.28	TINTED, LOW-E SUN	PICTURE	H-10/11	J-10/11	S-1/2	WOOD WINDOW W/ VINYL EXTERIOR CLADDING	ANDERSEN, P6040, PRAIRIE GRILLES
B	4'-11 1/4"	2'-11 1/4"	0.31	TINTED, LOW-E SUN	GLIDING	H-12	J-12	S-3	WOOD WINDOW W/ VINYL EXTERIOR CLADDING	ANDERSEN, G53, PRAIRIE GRILLES
C	3'-11 1/4"	2'-11 1/4"	0.31	TINTED, LOW-E SUN	GLIDING	H-12	J-12	S-3	WOOD WINDOW W/ VINYL EXTERIOR CLADDING	ANDERSEN, P43, PRAIRIE GRILLES
D	6'-0"	2'-0"	0.28	TINTED, LOW-E SUN	PICTURE	H-11	J-11	S-4	WOOD WINDOW W/ VINYL EXTERIOR CLADDING	ANDERSEN, CUSTOM, P6020, PRIVACY GLASS, PRAIRIE GRILLES
E	5'-0"	2'-8"	0.28	TINTED, LOW-E SUN	PICTURE	H-11	J-11	S-4	WOOD WINDOW W/ VINYL EXTERIOR CLADDING	ANDERSEN, CUSTOM, PRAIRIE GRILLES

- * U-VALUE BASED ON TOTAL UNIT
** UNIT MEASUREMENTS MAY VARY SLIGHTLY.
*** SEE THIS SHEET FOR DETAILS


STEEL LINTELS:
FOR OPENINGS UP TO 6' - 3"x3"x1/4"
FOR OPENINGS FROM 6'-12' - 4"x4"x3/8"
FOR OPENINGS OVER 12' - SEE STRUCTURAL PLANS
ALL STEEL LINTELS TO HAVE A MINIMUM OF 4" BEARING EACH SIDE

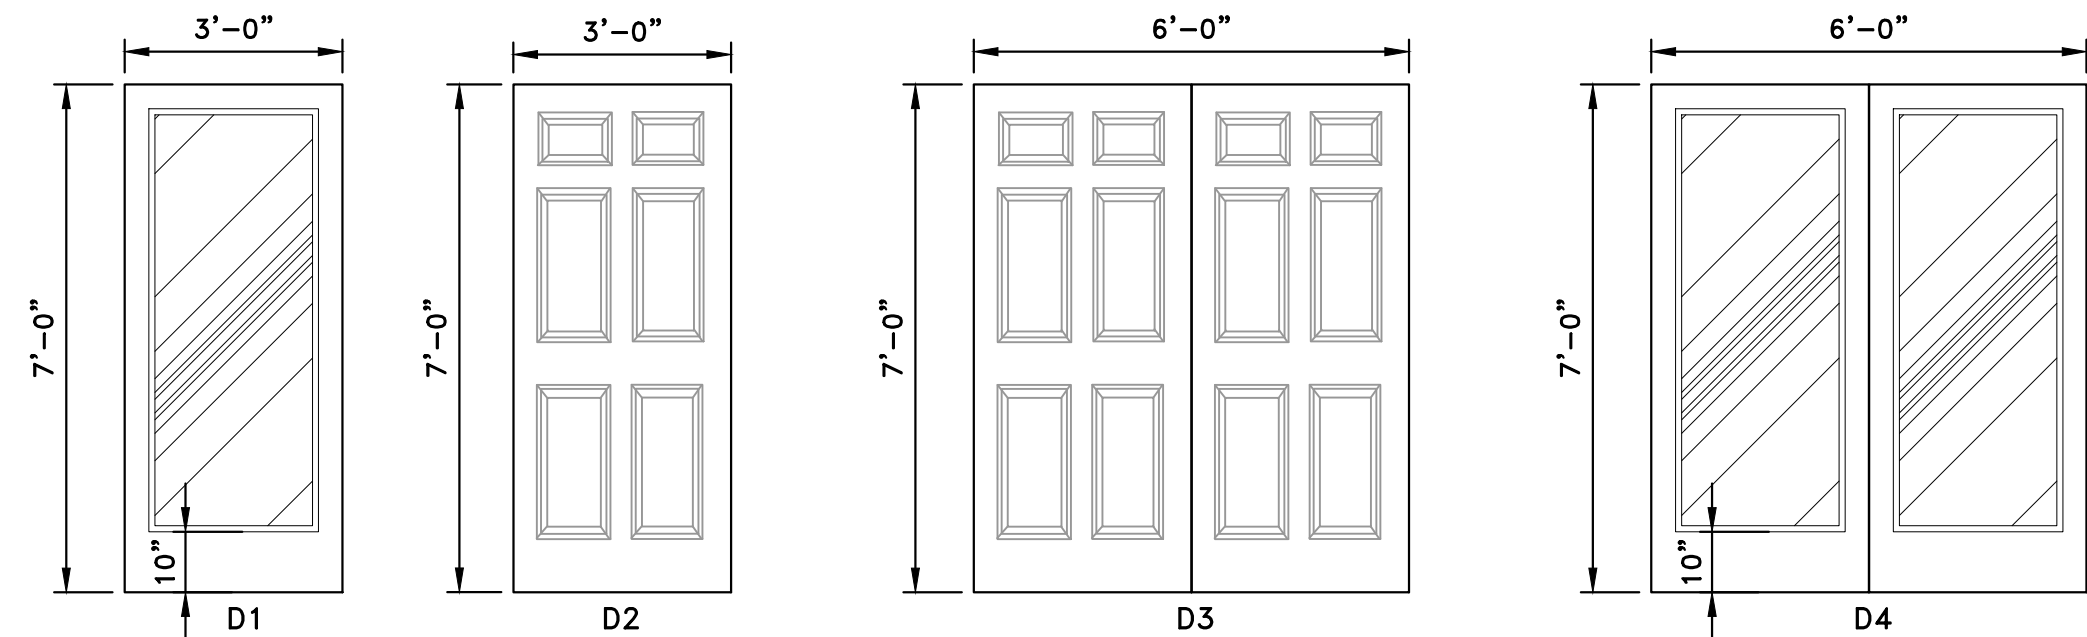

DOOR ELEVATIONS
SCALE: NONE

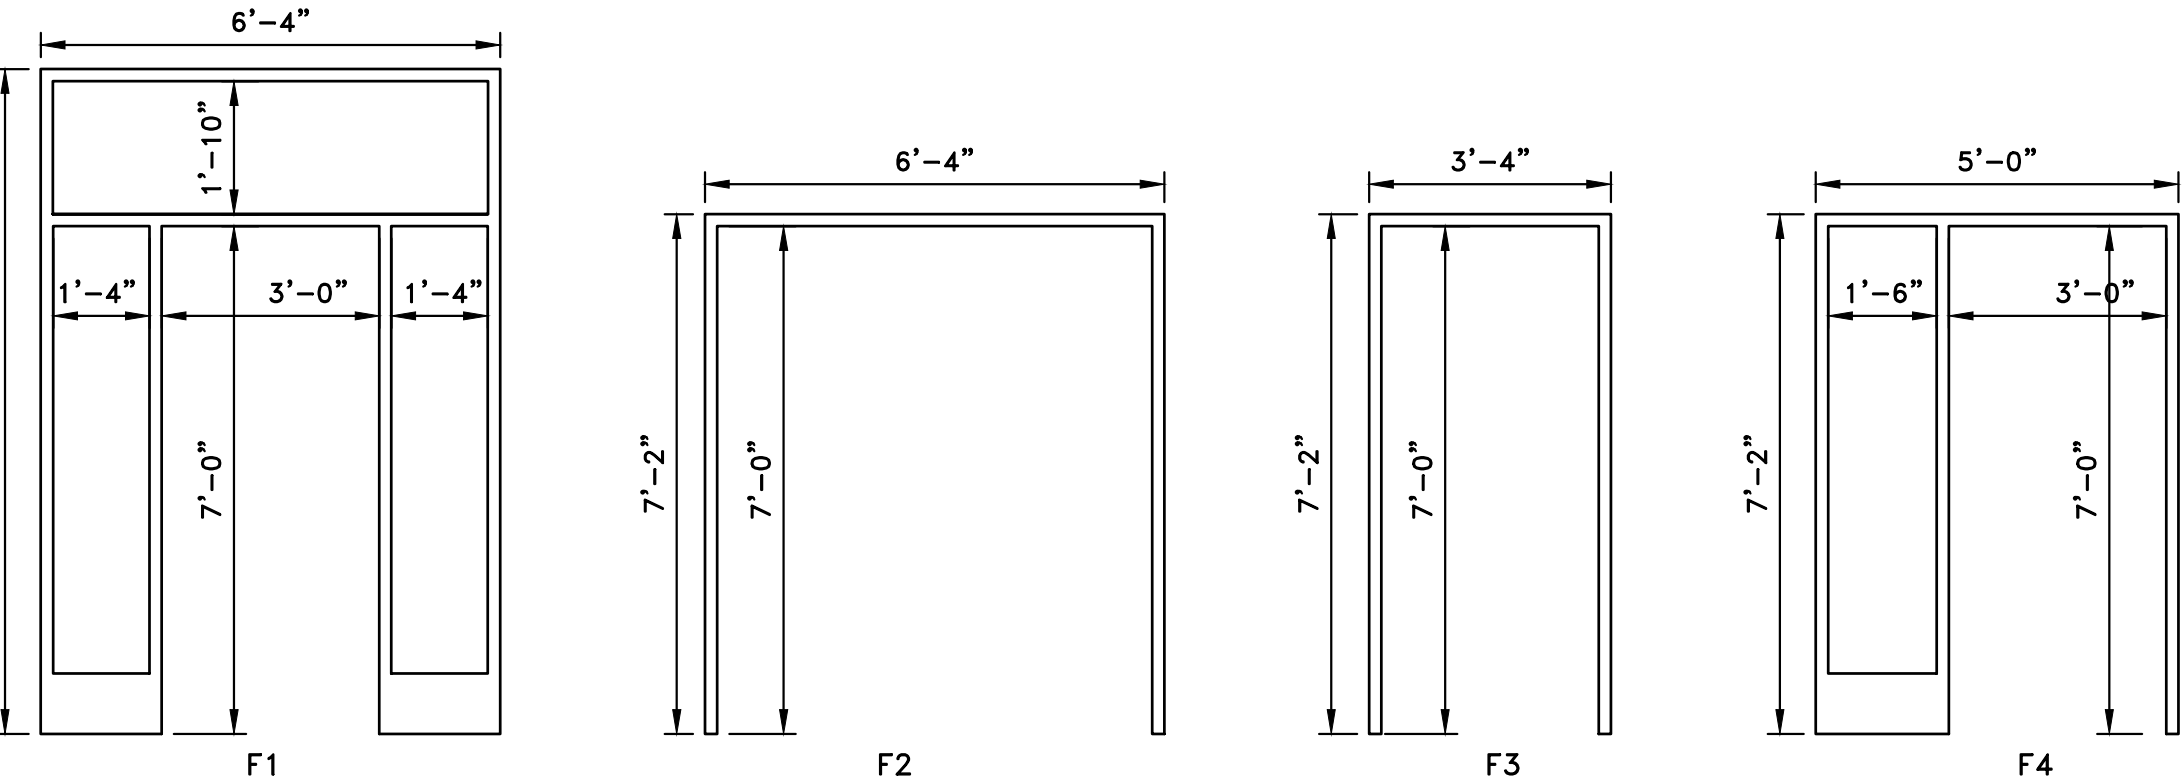

FRAME ELEVATIONS
SCALE: NONE

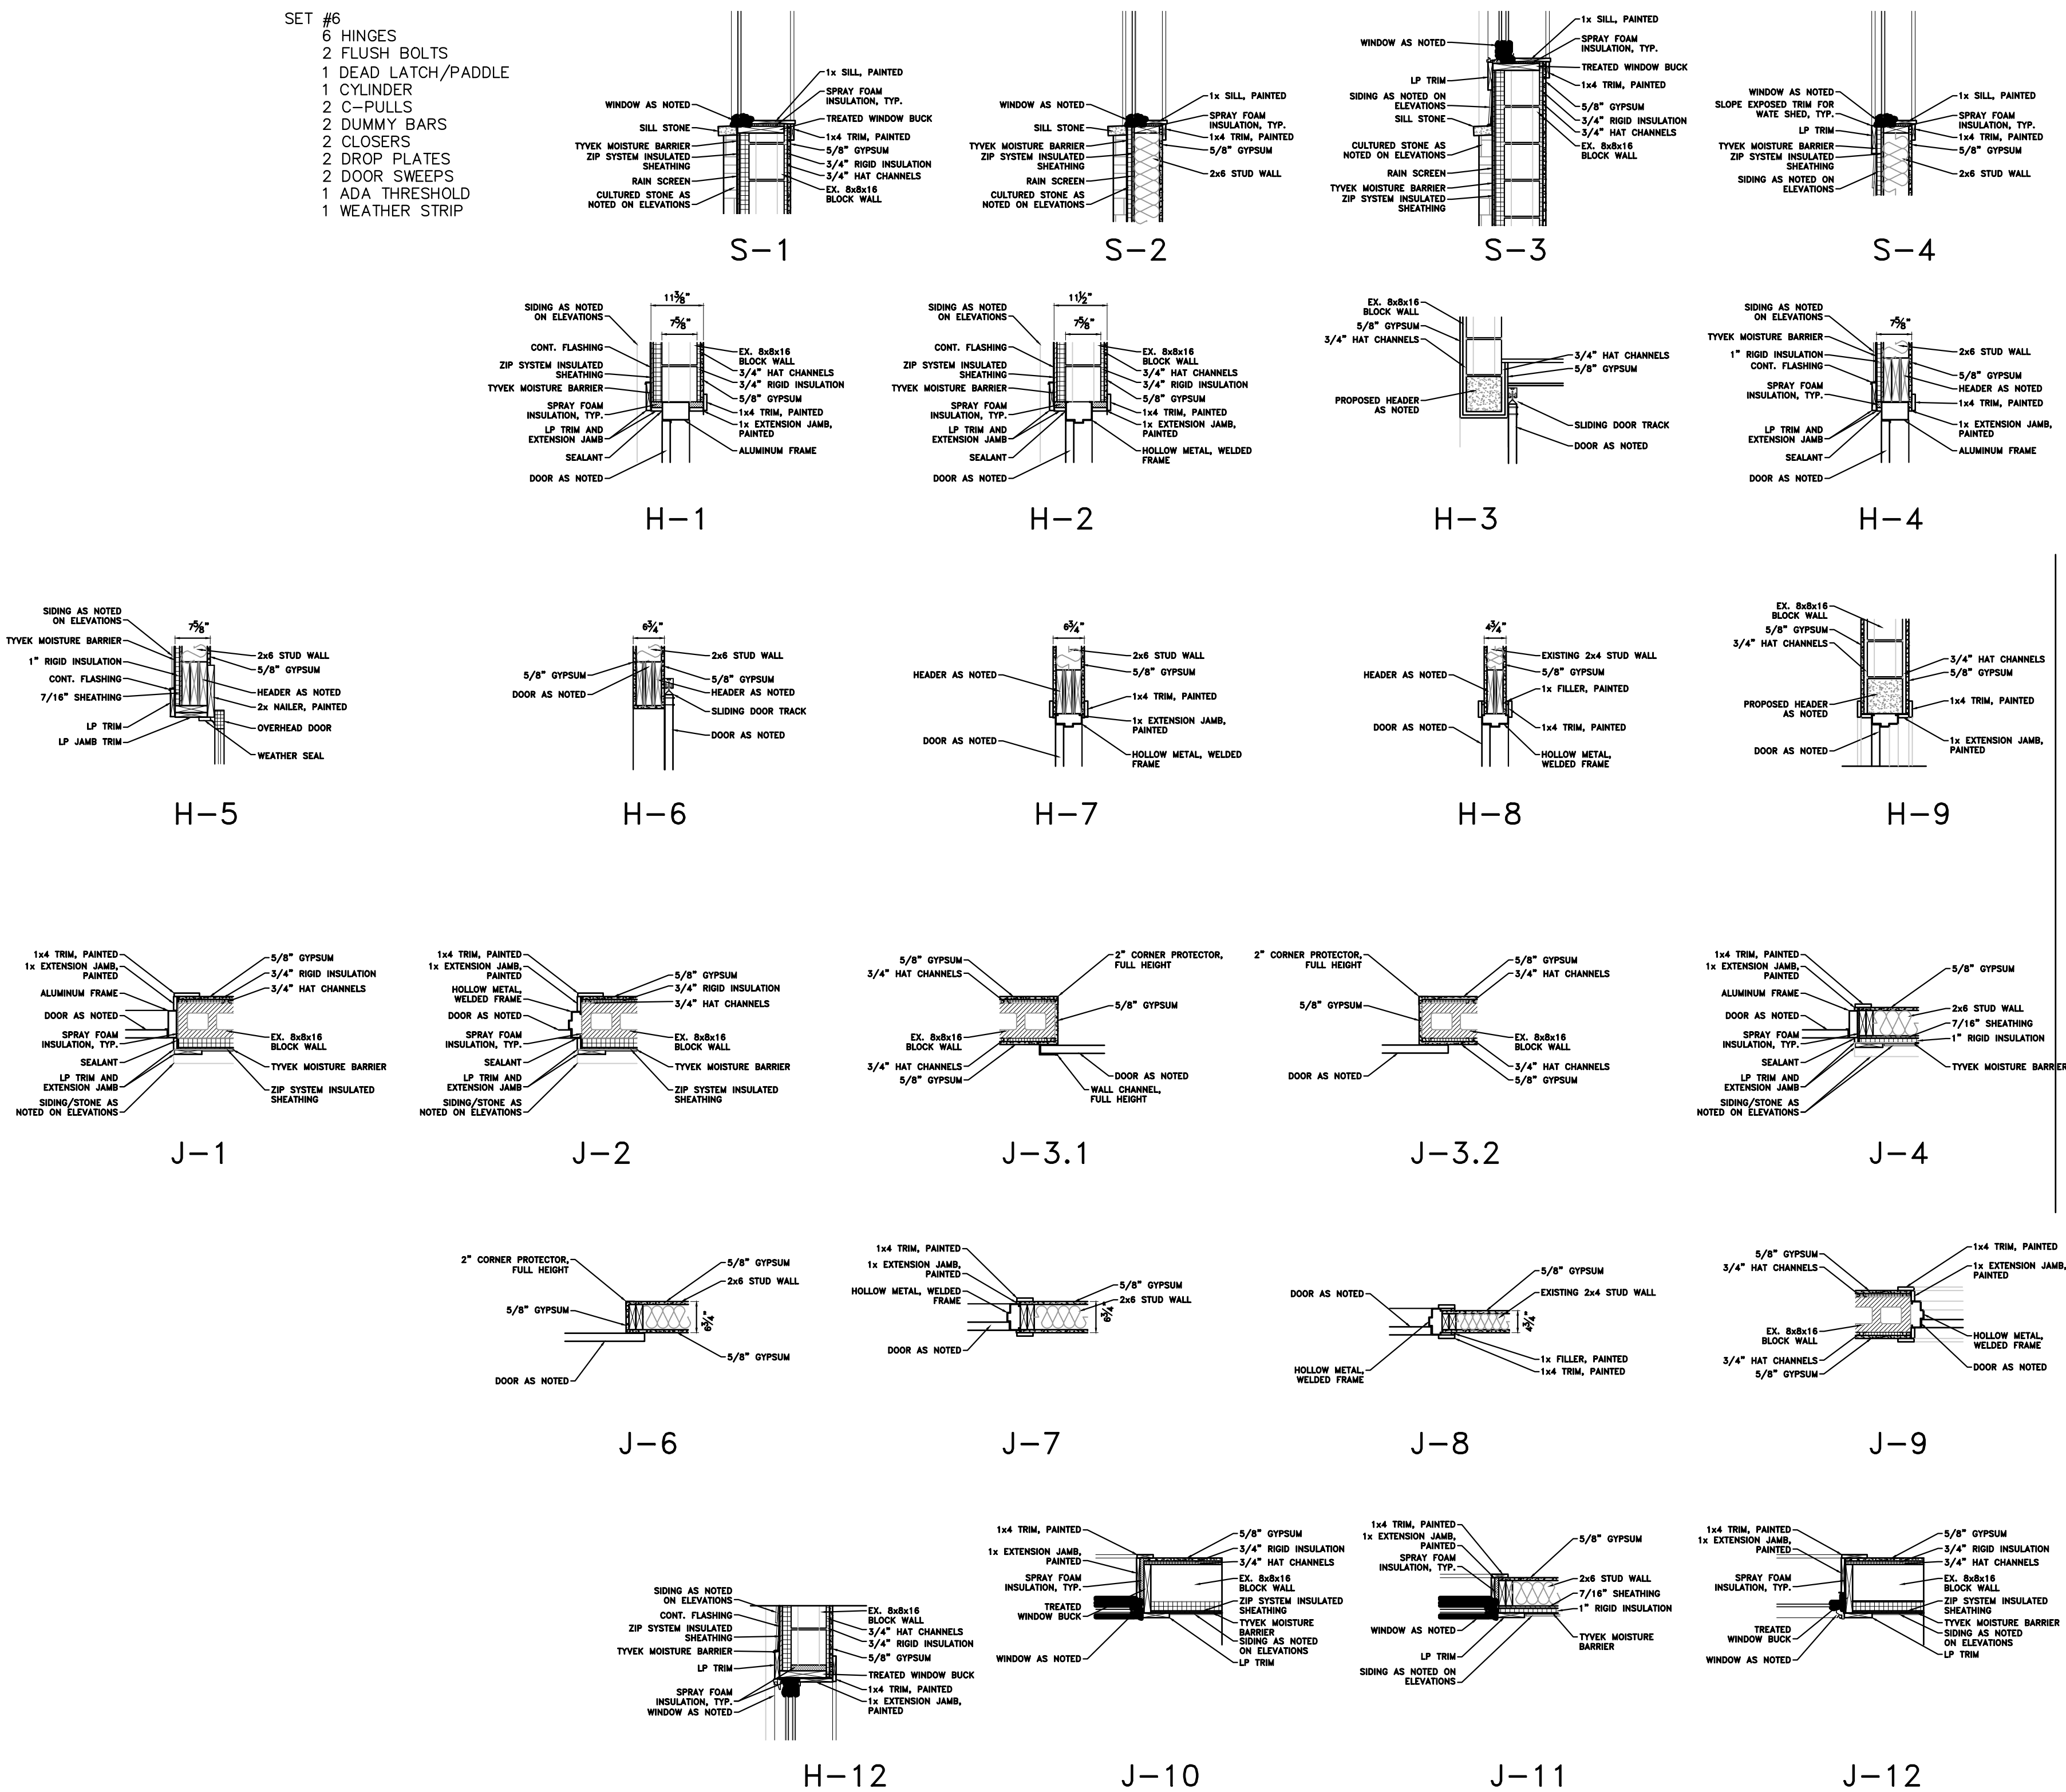

Project: DUNDEE CIVIC COMMUNITY CENTER				DAC Job #: 301006		Date: 11/17/2025								
INTERIOR FINISH SCHEDULE														
Room Number	Room Name	Floor	Walls			Base	Ceiling	Height	Notes					
		LVCT	Sealed Concrete	Paint	Epoxy Paint	Wood Paneling Wainscot (paint)	FRP Wainscot	4" Rubber	6" Rubber	ACT	Paint on Gypsum	Stain on Wood		
100	Patio	O	O					O				O	9'-8 1/2"	
101	Assembly Hall	O		O		O		O		O			8'-6"	
104	Women's Toilet Room	O			O	O	O	O		O			9'-0"	
105	Vestibule	O		O		O		O		O			9'-0"	
106	Men's toilet Room	O			O		O	O		O			9'-0"	
107	Mechanical	O	O		O			O		O			9'-0"	
108	Storage	O		O				O		O			9'-0"	
109	Warming Kitchen	O		O				O		O			8'-6"	



FOR BID PURPOSES ONLY

DUNDEE CIVIC COMMUNITY CENTER
165 VAN NEST STREET
DUNDEE, MICHIGAN 48131
VILLAGE OF DUNDEE, MONROE COUNTY

DEVELOPER/OWNER:
VILLAGE OF DUNDEE
MICHAEL HOFFMEISTER, VILLAGE MANAGER
350 WEST MONROE ST.
DUNDEE, MI 48131
(734) 529-3430

ISSUE	DATE	BY	REVIEWED BY
FOR BID ONLY	11/17/25	KI	
ADDENDUM No.2	12/10/25	KI	


SCALE* AS NOTED
PLOT DATE 12/10/25
JOB NO. 306001
SHEET NO.

A4.02

[illegible]



BEAM/HEADER SCHEDULE		
LABEL	SIZE/MATERIAL	REMARKS
A	8"x8" PRECAST CONCRETE	NEW HEADER IN EXISTING MASONRY WALL
B	3-1 3/4"x9 1/2" 2.0E MICROLLAM LVL	NEW HEADER IN NEW CONSTRUCTION, STUD WALL
C	W12x35	ROOF BEAM
D	2-1 3/4"x9 1/2" 2.0E MICROLLAM LVL	NEW HEADER IN NEW CONSTRUCTION, STUD WALL
E	2-1 3/4"x11 7/8" 2.0E MICROLLAM LVL	NEW HEADER ON EXISTING MASONRY WALL

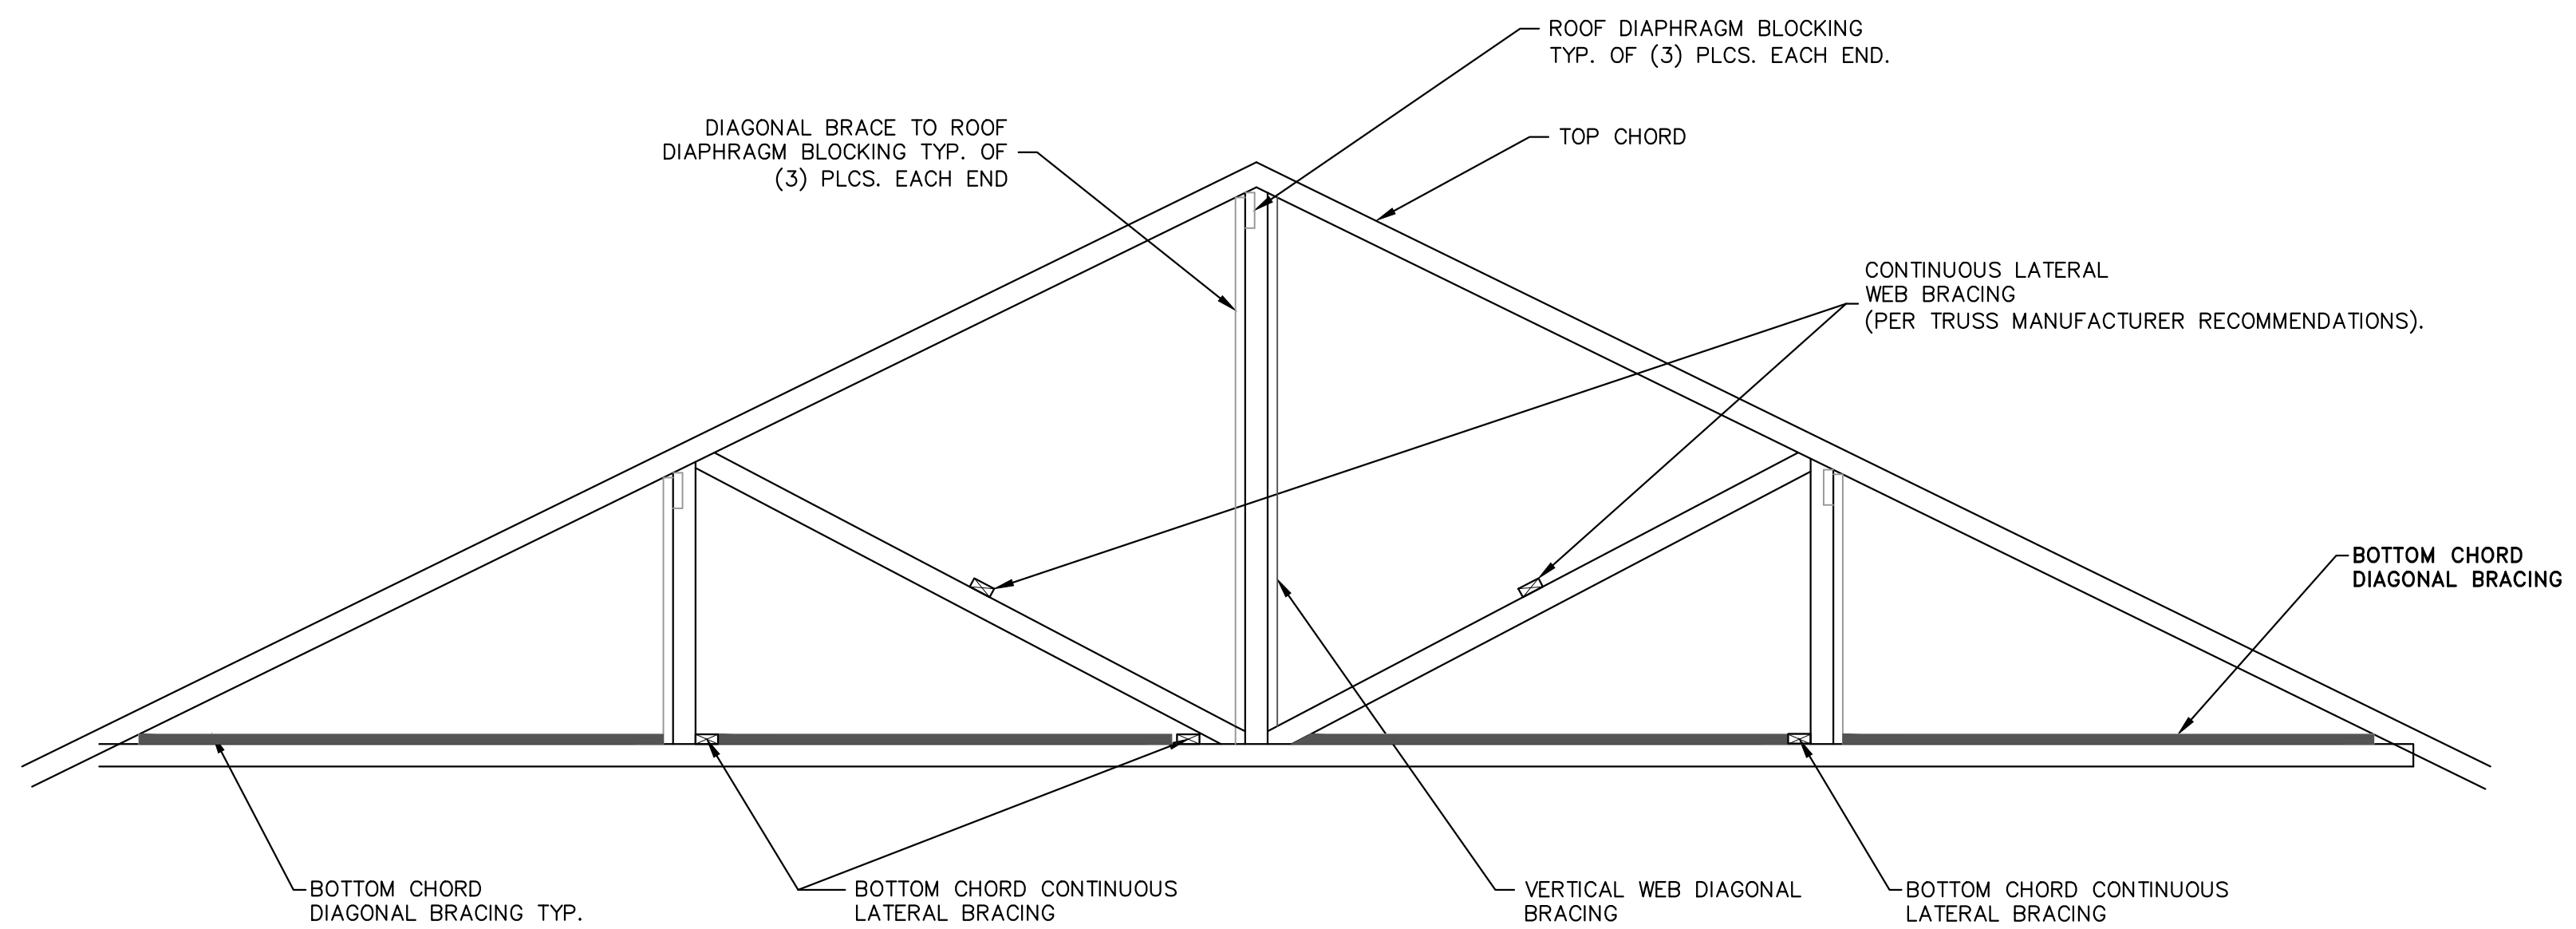

A TYPICAL COMMON TRUSS BRACING
SCALE: NONE

THE LOCATION AND ELEVATION OF EXISTING UNDERGROUND UTILITIES AS SHOWN ON THESE DRAWINGS ARE ONLY APPROXIMATE. NO GUARANTEE IS EITHER EXPRESSED OR IMPLIED AS TO THE COMPLETENESS OR ACCURACY THEREOF. THE CONTRACTOR SHALL BE EXCLUSIVELY RESPONSIBLE FOR DETERMINING THE EXACT LOCATION AND ELEVATION OF EXISTING UTILITIES AND PROPOSED UTILITY CROSSINGS IN THE FIELD PRIOR TO CONSTRUCTION. THE CONTRACTOR SHALL NOTIFY THE ENGINEER IF ANY CONFLICTS ARE APPARENT OR IF THE LOCATION OR DEPTH DIFFERS SIGNIFICANTLY FROM THE PLANS.

NOTE: DO NOT SCALE DRAWING, USE PRINTED DIMENSIONS ONLY. IF DRAWING IS REPRODUCED IN A SIZE OTHER THAN 24" x 36", SCALE MAY DIFFER. THIS DRAWING SHALL NOT BE DUPLICATED, MODIFIED, TRANSFERRED OR ISSUED WITHOUT THE WRITTEN CONSENT OF DAVID ARTHUR CONSULTANTS, INC. - COPYRIGHT 2025

1. DRAFT STOPPING SHALL BE PROVIDED IN THE ATTIC WITH A MAXIMUM CONCEALED SPACE OF 3000 S.F. (MBC 717.4.3)
2. DRAFT STOP MATERIAL SHALL BE 1/2" GYPSUM BOARD OR 3/8" OSB ON ONE SIDE OF A COMMON TRUSS. DRAFT STOPPING SHALL BE RUN TIGHT FROM 1/2" GYPSUM CEILING AT BOTTOM OF TRUSSES TO ROOF DECK.
3. ANY OPENINGS IN ANY DRAFT STOP SHALL BE EQUIPPED W/ AN AUTOMATIC CLOSER AND AUTOMATIC LATCH.

ROOF VENTILATION (MBC SECTION 1203)
NET FREE VENTILATION AREA SHALL NOT BE LESS THAN 1/300 OF THE AREA OF THE SPACE VENTILATED, WITH 50 PERCENT OF THE REQUIRED VENTILATING AREA WITHIN 3' OF PEAK/RIDGE VENTS WITH THE BALANCE OF THE VENTILATION PROVIDED BY EAVE/SOFFIT.

FLOOR AREA: 3080 SQ.FT.
10.26 SQ.FT. VENTILATION REQUIRED
5.13 SQ.FT. MIN. @ SOFFIT
5.13 SQ.FT. MIN. WITHIN 3' OF PEAK/RIDGE VENT

SOFFIT VENT:
72.75 L.F. OF SOFFIT O.H. AVAILABLE
* 1.5 FT. SOFFIT DEPTH = 109.12 SQ.FT. AVAILABLE

MINIMUM VENTILATION AREA REQUIRED PER SQ.FT. OF SOFFIT:
6.76 SQ.IN./SQ.FT.

RIDGE VENT:
MINIMUM VENTILATION REQUIRED: 5.13 S.F.

RIDGE VENT AVAILABLE: 109.25 L.F.

RIDGE VENT NET FREE AREA REQUIRED: 6.76 SQ. IN./L.F..

VERIFY FINAL MATERIAL VENTILATION RATES. A MIN. OF 40% AND MAXIMUM OF 50% OF THE OVERALL PROVIDED VENTILATION SHALL BE AT THE RIDGE.

1. WEB CONFIGURATION AND TRUSS LAYOUT TO BE DETERMINED BY TRUSS MANUFACTURER. TRUSS MANUFACTURER SHALL PROVIDE A COMPLETE TRUSS SYSTEM WHICH INCLUDES ALL TRUSSES, TEMPORARY AND PERMANENT BRACING, LVL's AND HEADER/BEAMS USED FOR THE ROOF FRAMING.
2. TRUSS MANUFACTURER TO SUBMIT ENGINEERED STAMPED TRUSS DESIGN DRAWINGS SHOWING ALL DESIGN LOADS FOR TRUSS DESIGN, INCLUDING WIND & SNOW LOADS, LUMBER SPECIFICATIONS AND ALL ITEMS AS REQUIRED PER THE CURRENT BUILDING CODE
3. DEFLECTION: LIVE LOAD= $L/240$, TOTAL LOAD= $L/240$.
4. MINIMUM TRUSS MEMBER SIZE TO BE 2x4 (2x3 NOT ALLOWED). SPF NO. 2 OR BETTER.
5. A MINIMUM OF 1 1/2" BEARING SHALL BE PROVIDED AT ALL HEADERS FOR OPENINGS LESS THAN 6', U.N.O. A MINIMUM OF 3" OF BEARING SHALL BE PROVIDED AT ALL HEADERS WITH SPANS 6' TO 12', U.N.O. VERIFY WITH DETAILED STRUCTURAL INFORMATION FOR THE REQUIRED BEARING SUPPORT OF LARGER OPENINGS AND OTHER STRUCTURAL MEMBERS.
6. 3 SETS OF PRE-ENGINEERED WOOD ROOF TRUSS SHOP DRAWINGS SHALL BE PROVIDED TO DAC, INC. FOR REVIEW AND COORDINATION WITH THE CONSTRUCTION DOCUMENTS IN ACCORDANCE WITH MBC SECTION 106.3.4. THESE APPROVED DOCUMENTS SHALL BE A DEFERRED SUBMITTAL TO THE OFFICE OF THE BUILDING OFFICIAL FOR REVIEW AND REFERENCE PRIOR TO INSTALLATION OF SUCH TRUSSES.


FOR BID
PURPOSES
ONLY

**DUNDEE CIVIC
COMMUNITY CENTER**
165 VAN NEST STREET
DUNDEE, MICHIGAN 48131
VILLAGE OF DUNDEE, MONROE COUNTY

**ROOF FRAMING
PLAN & DETAILS**

DEVELOPER/OWNER:

VILLAGE OF DUNDEE
MICHAEL HOFFMEISTER, VILLAGE MANAGER
350 WEST MONROE ST.
DUNDEE, MI 48131
(734) 529-3430

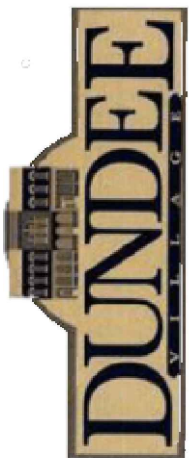[illegible]

SCALE* AS NOTED









PLOT DATE 11/17/25

 
 
 
 
JOB NO. 301006

SHEET NO


\$3.00



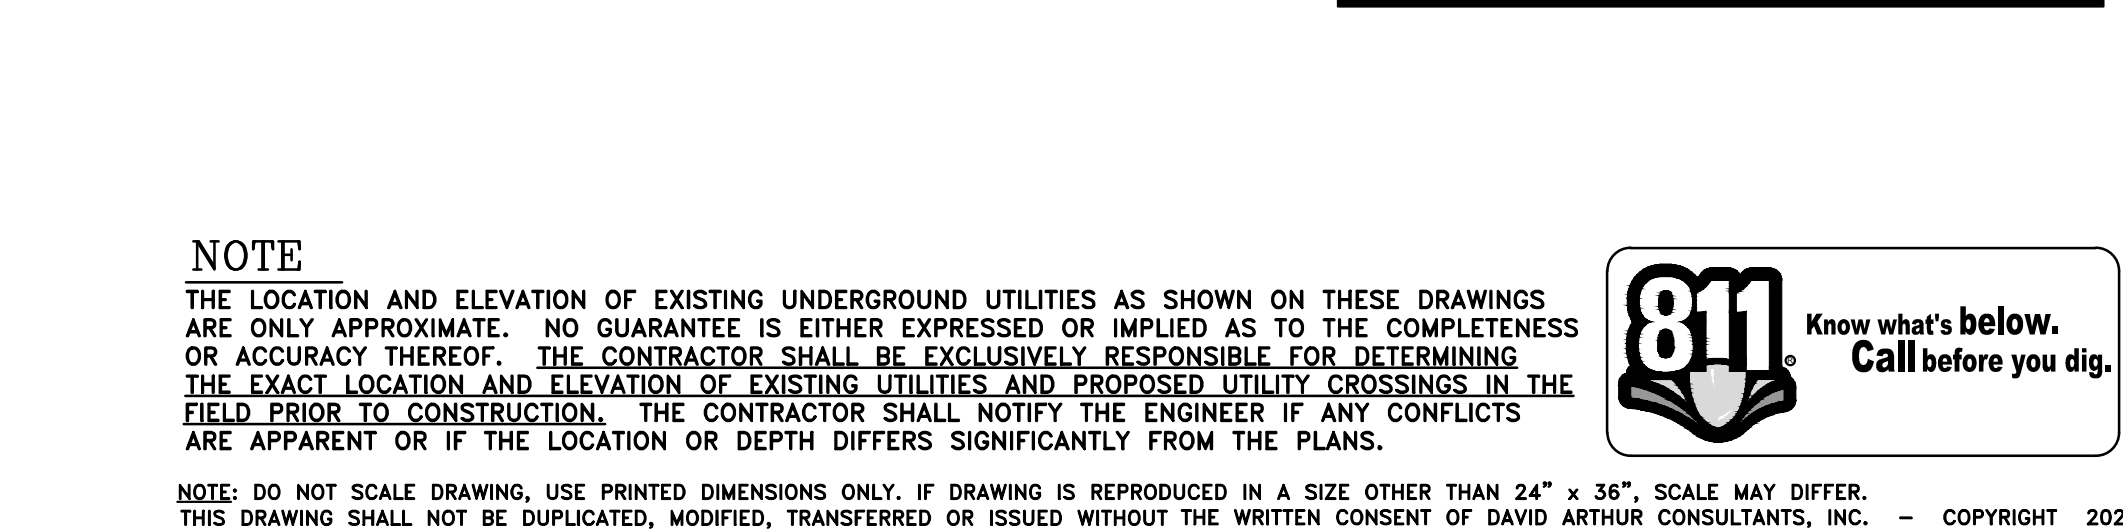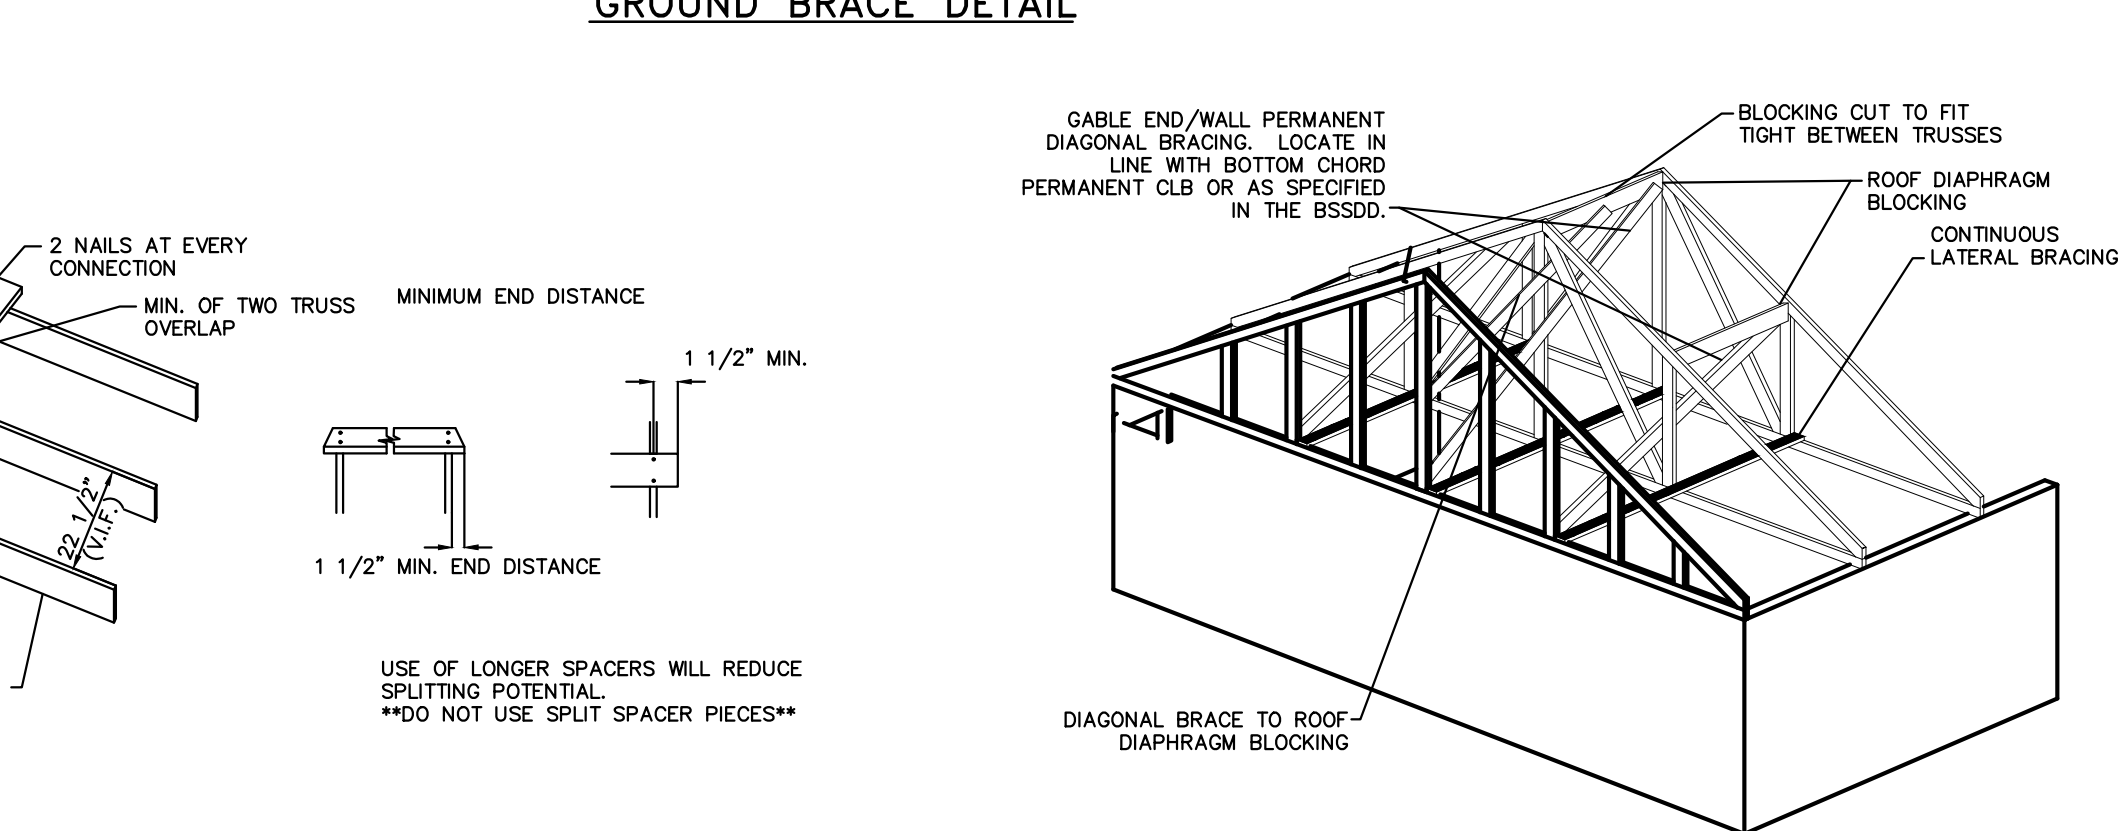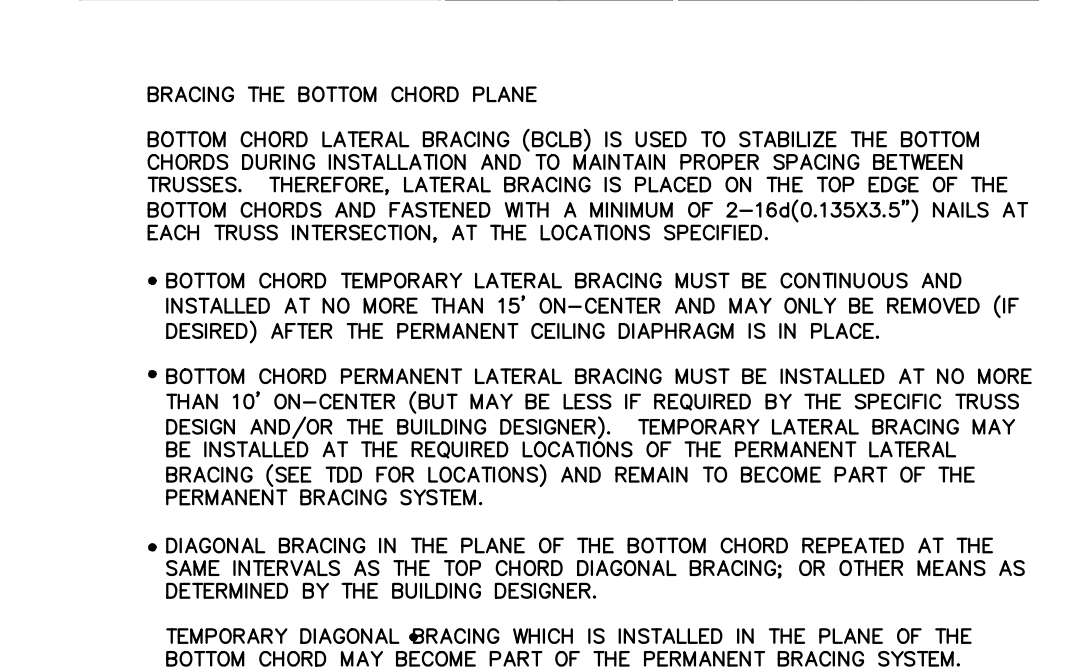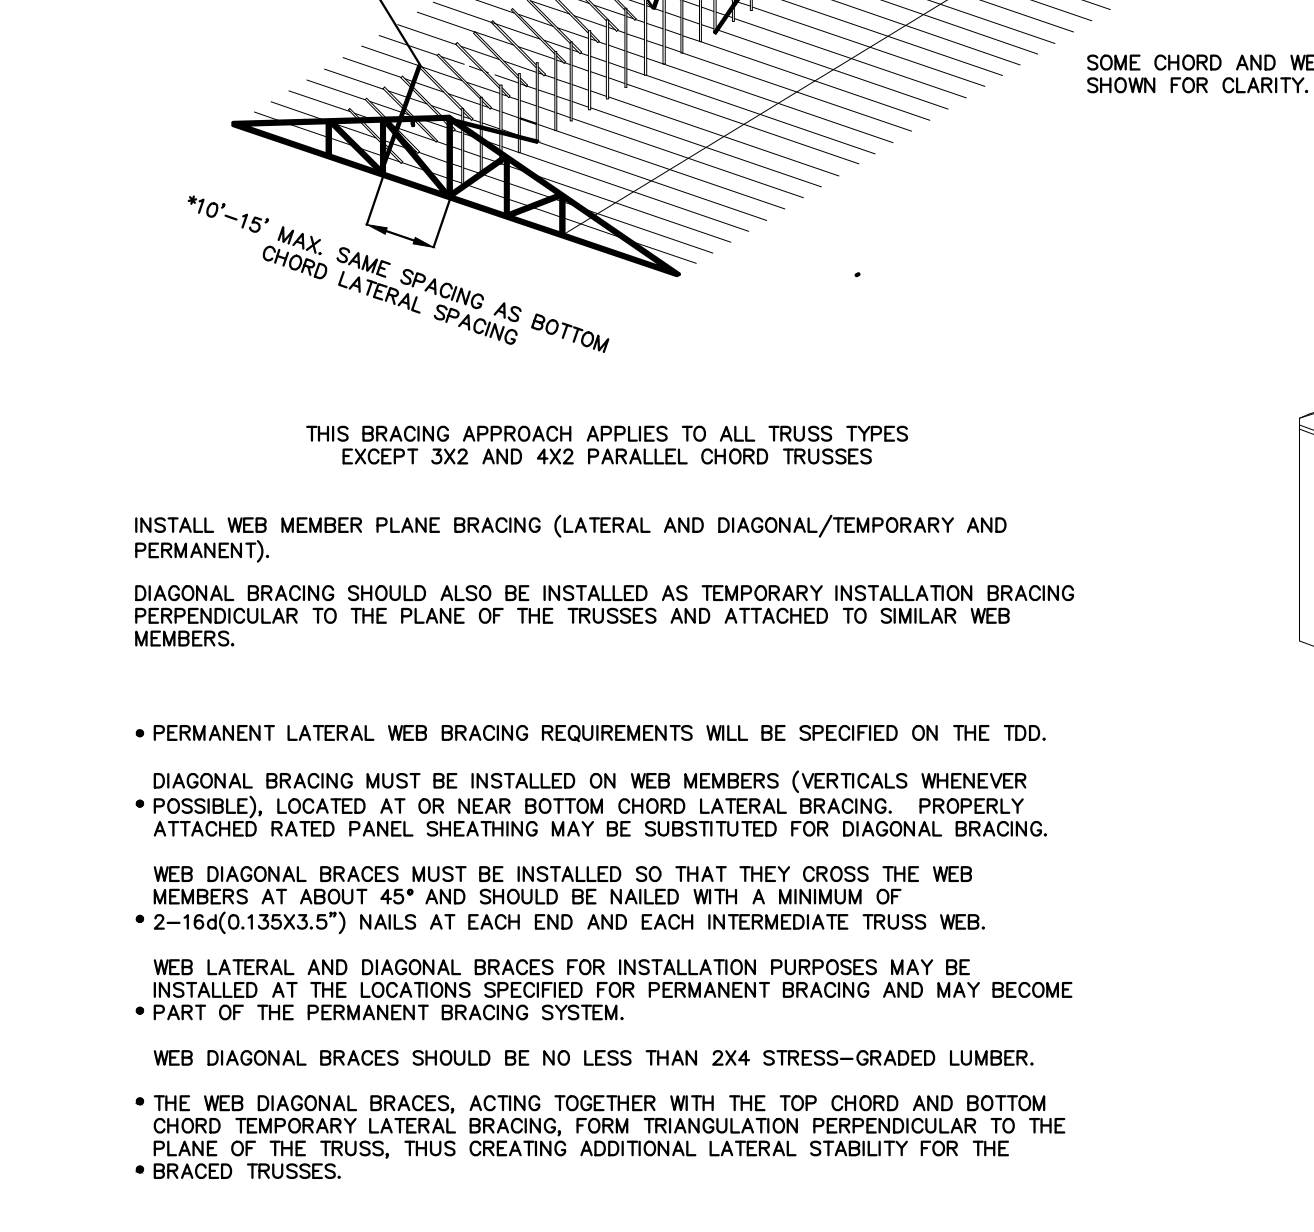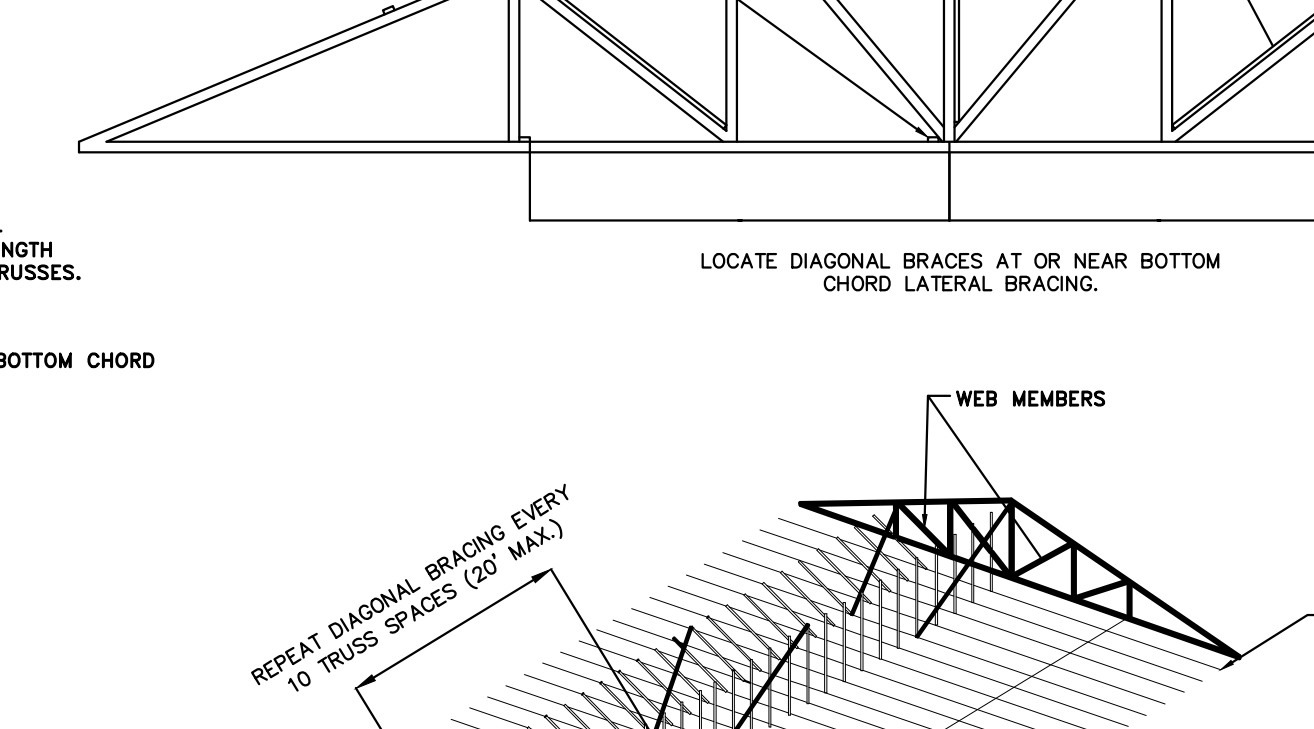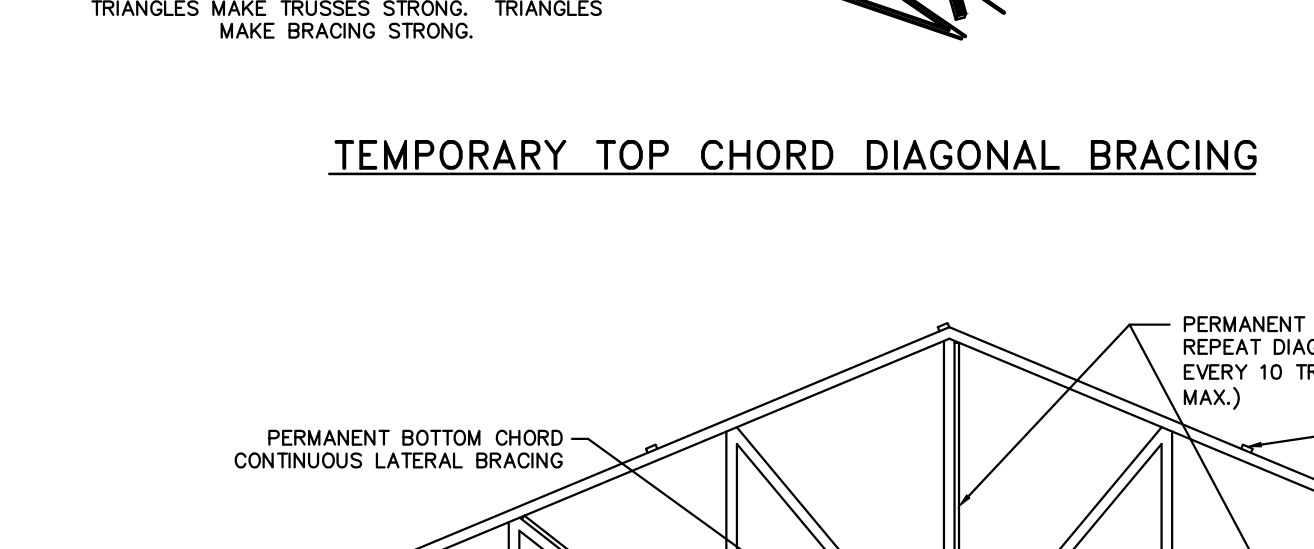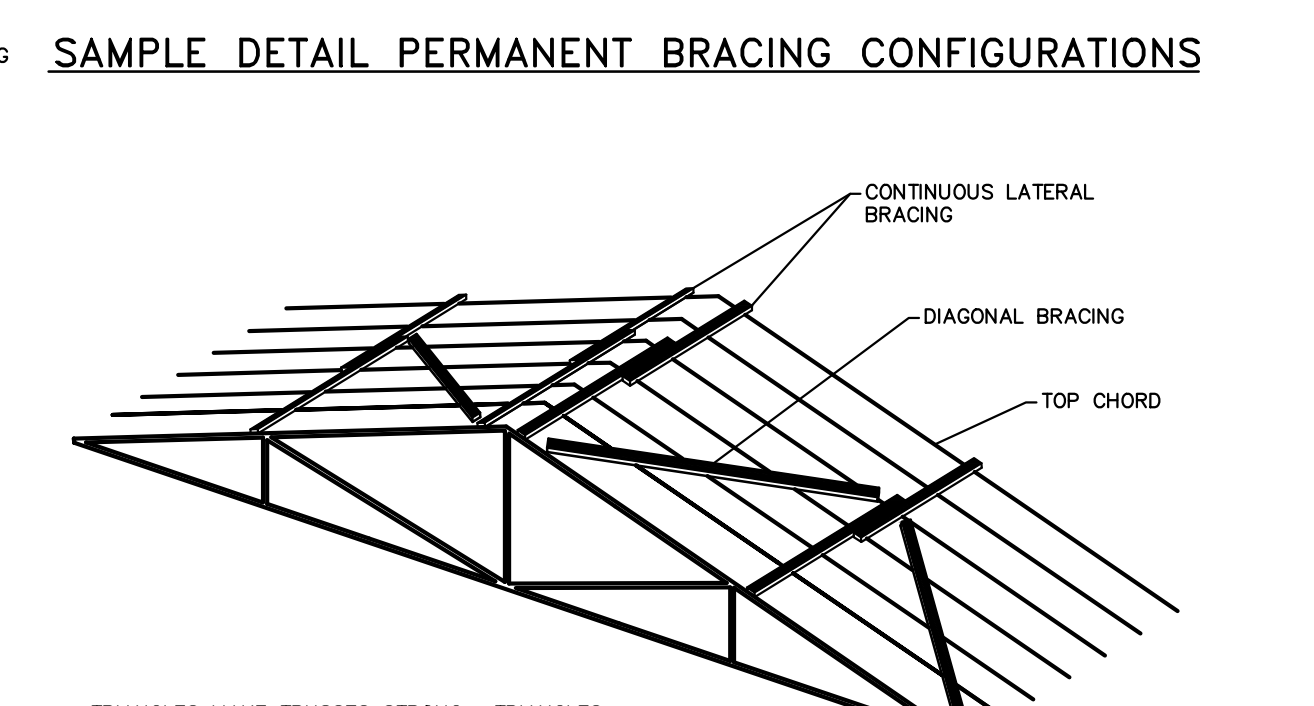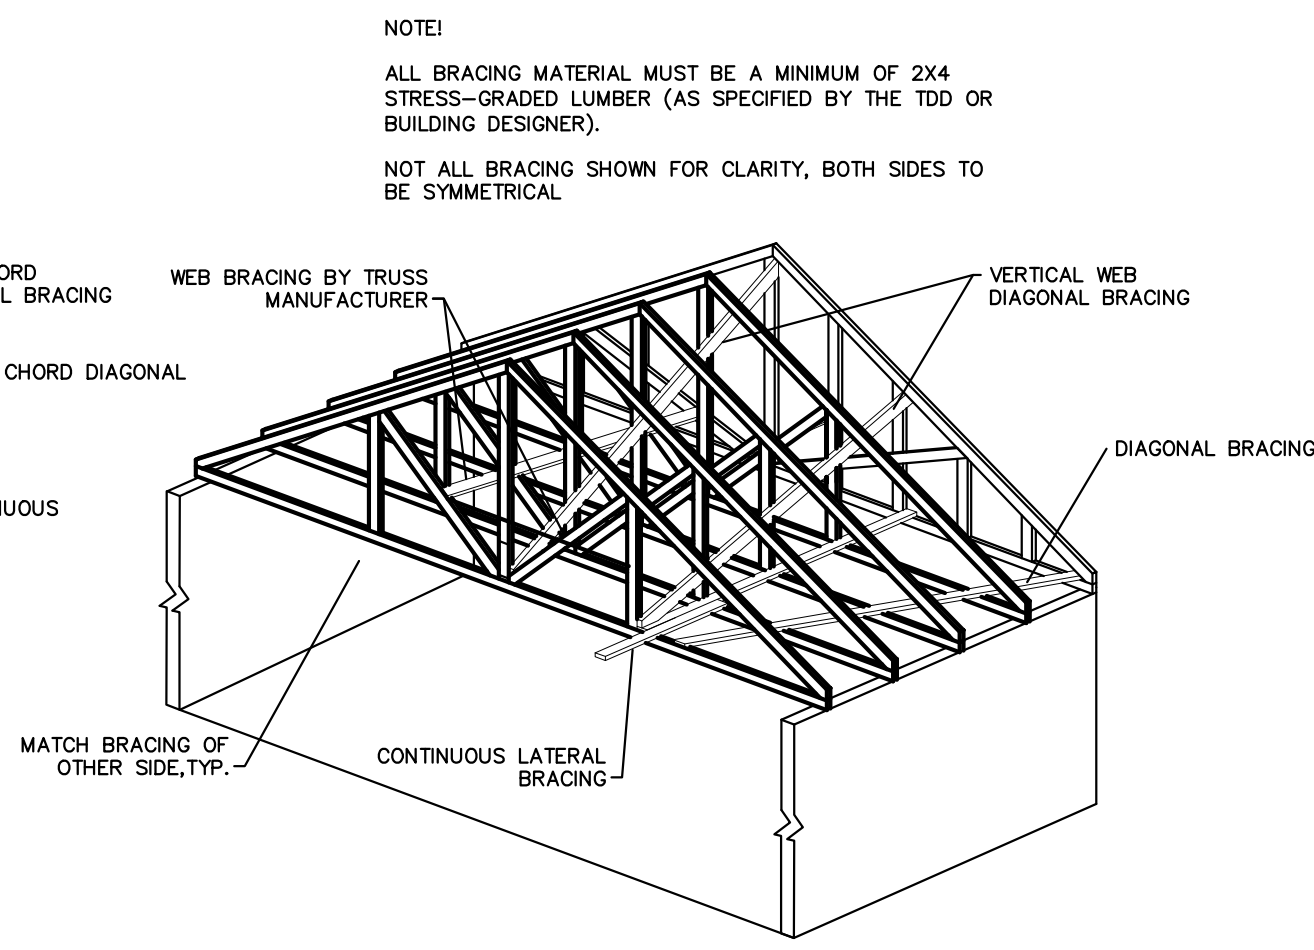



**TOP PLATE TO RUN
IN-LINE WITH BEAM

 

STEEL DETAILS

THE LOCATION AND ELEVATION OF EXISTING UNDERGROUND UTILITIES AS SHOWN ON THESE DRAWINGS ARE ONLY APPROXIMATE. NO GUARANTEE IS EITHER EXPRESSED OR IMPLIED AS TO THE COMPLETENESS OR ACCURACY THEREOF. THE CONTRACTOR SHALL BE EXCLUSIVELY RESPONSIBLE FOR DETERMINING THE EXACT LOCATION AND ELEVATION OF EXISTING UTILITIES AND PROPOSED UTILITY CROSSINGS IN THE FIELD PRIOR TO CONSTRUCTION. THE CONTRACTOR SHALL NOTIFY THE ENGINEER IF ANY CONFLICTS ARE APPARENT OR IF THE LOCATION OR DEPTH DIFFERS SIGNIFICANTLY FROM THE PLANS.

NOTE: DO NOT SCALE DRAWING, USE PRINTED DIMENSIONS ONLY. IF DRAWING IS REPRODUCED IN A SIZE OTHER THAN 24" x 36", SCALE MAY DIFFER. THIS DRAWING SHALL NOT BE DUPLICATED, MODIFIED, TRANSFERRED OR ISSUED WITHOUT THE WRITTEN CONSENT OF DAVID ARTHUR CONSULTANTS, INC. - COPYRIGHT 2025



FOR BID
PURPOSES
ONLY

DETAILS

VILLAGE OF DUNDEE
MICHAEL HOFFMEISTER, VILLAGE MANAGER
350 WEST MONROE ST.
DUNDEE, MI 48131
(734) 529-3430

[illegible]

SCALE* AS NOTED

PLOT DATE 11/17/25

JOB NO. 301006

SHEET NO

S4.01

FIXTURE & ACCESSORY SCHEDULE

SYMBOL	DESCRIPTION	PIPE CONNECT.				MFG'R.	REMARKS/MODEL NO.*
		WASTE	VENT	H.W.	C.W.		
WC	WATER CLOSET	3"	2"	—	1/2"	KOHLER	HIGHLINE. COMFORT HEIGHT— FLOOR MOUNTED, ELONGATED TWO PIECE TOILET (K-76301), 1.28 GPF, OPEN SIDE TRIP LEVER, LUSTRA COLORS: WHITE
UR	URINAL	2"	1 1/2"	—	3/4"	KOHLER	DEXTER (K-5016) SIPHON JET URINAL, VITREOUS CHINA, 3/4" TOP SPUD, INLET/OUTLET SPUDS & HANGERS INCLUDED, ANTI-BACKPLASH WALL, 0.5 GPF, 14 1/2" EXTENDED RIM ZURN (ZER6003AV-EWS) FLUSH VALVE
LAV	LAVATORY	2"	1 1/2"	—	—	KOHLER	SOHO, WALL-MOUNT LAVATORY— VITREOUS CHINA, OVERFLOW, ADA COMPLIANT, CONCEALED ARM CARRIER SYSTEM, DRAIN TRAP, GRID DRAIN. COLOR WHITE.
F-1	LAVATORY FAUCET	—	—	1/2"	1/2"	ZURN	AQUASENSE, ADA COMPLIANT, BATTERY POWERED, POLISHED CHROME-PLATED CAST BRASS CONSTRUCTION W/ INFRARED PROXIMITY SENSOR, 0.5 GPM AERATOR, 30 SECOND TIMEOUT, INLINE FILTER (Z6913-XL)
KS	KITCHEN SINK	2"	2"	1/2"	1/2"	AMERICAN STANDARD	COLONY 33x22 ADA STAINLESS STEEL DOUBLE BOWL KIT — 14"x16"x6" BOWLS, 3-HOLE, 20 GAUGE STAINLESS STEEL, TOP MOUNT, TWO BASKETS AND DRAINS, WITH COLONY PRO SINGLE CONTROL FAUCET WITH DECK PLATE, 1.5 GPM FLOW, LEAD FREE, INTEGRATED BRAIDED STAINLESS STEEL SUPPLY LINES, ADA COMPLIANT (22DB.6332283C.075)
SS	SERVICE SINK	2"	2"	—	—	ZURN	MOP SERVICE BASIN— FLOOR MOUNTED MOLDED HIGH DENSITY COMPOSITE BASIN, PVC DRAIN BODY AND STAINLESS STEEL DOME STRAINER (Z-1996-24) 36" HOSE AND BRACKET, STAINLESS STEEL MOP HANGER, WALL GUARDS— 2-24"x36".
F-2	SERVICE SINK FAUCET	—	—	1/2"	1/2"	ZURN	SINK FAUCET (Z843M4). POLISHED CHROME-PLATED CAST BRASS 8" SINK FAUCET W/ QUARTER TURN CERAMIC DISC CARTRIDGES, 3/8" SHORT SWIVEL INLETS W/ ADJUSTABLE CENTERS, INTEGRAL SERVICE STOPS, 6" CENTERLINE CAST BRASS SPOUT W/ CHEMICAL RESISTANT VACUUM BREAKER, 3/4" HOSE THREADED OUTLET, PAIL HOOK AND ADJUSTABLE WALL BRACE, TWO 4" VANDAL-RESISTANT COLOR-CODED METAL WRIST BLADE HANDLES.
FD	FLOOR DRAIN	2"	—	—	—	ZURN	BODY ASSEMBLY W/TYPE "B" STRAINER— ADJUSTABLE HEIGHT, TRAP W/ TRAP PRIMER CONNECTION EITHER INDIVIDUAL OR FROM DISTRIBUTION BLOCK, ROUND STRAINER W/SQUARE OPENINGS.
CO	CLEAN OUT	2"	—	—	—	ZURN	ADJUSTABLE FLOOR CLEANOUT. LIGHT-DUTY APPLICATIONS AND FOOT TRAFFIC, PVC BODY, ADJUSTABLE NICKLE COVER AND AN ABS TAPER THREAD PLUG. DIAMETER SIZE TO MATCH SANITARY LINE AT CLEANOUT LOCATION AS SHOWN ON PLANS.
WH	WATER HEATER	—	—	3/4"	3/4"	BRADFORD WHITE	CONDENSING GAS TANKLESS WALL-MOUNTED, INFINITI GR RTGR199N1, BUILT-IN DIGITAL CONTROL, BUILT-IN RECIRCULATION PUMP AND DEDICATED RECIRCULATION CONNECTION, 199,000 BTUH MAX. INPUT, NOMNAL FLOW RATE OF 5.1 GPM AT 77 DEGREE RISE. 11:1 TURNDOWN RATIO, NATURAL GAS PRESSURE 3.5"-10.5", MINIMAL 18,000 BTUH INPUT. DUAL HEAT EXCHANGER WITH STAINLESS STEEL PRIMARY AND SECONDARY, FILTERED 3/4" INLET AND 3/4" OUTLET. 3" VENT TO EXTRIOR. ENERGY SAVER, STAINLESS STEEL HEAT EXCHANGER, , AHRI CERTIFIED
BC	BABY CHANGING STATION	—	—	—	—	KOALA	HORIZONTAL, HIGH IMPACT POLYETHYLENE WITH MICROBAN ANTIMICROBIAL ADDITIVE, REINFORCED STEEL-ON-STEEL HINGE MECHANISM ON METAL MOUNTING CHASSIS, , HIDDEN PNEUMATIC GAS SPRINGS, IMPERVIOUS TPU SAFETY STRAP, DUAL CAVITY SANITARY BED LINER DISPENSER, INSTALLED IN ACCORDANCE WITH ADA REQUIREMENTS, COLOR WHITE.
DF	WATER COOLER	1 1/2"	1 1/2"	—	3/8"	OASIS	MODEL PG8SBFSL, 8 GPM (CHILLED) WITH VERSAFILLER SPORTS BOTTLE FILLER WITH INDEPENDENT MANUAL ACTIVATION, BI-LEVEL, FOUR PUSH PADS, WATER SAVE BUBBLER, FLEXIBLE GUARD, POWDER COATING ON GALVANIZED STEEL CABINET, R-134A REFRIGERANT, ADA COMPLIANT, ANSI/NSF 61, 115/1/60, 20 MIN. GFCI BREAKER
TD-2	PAPER TOWEL DISPENSER	—	—	—	—	BOBRICK	CONTURA SERIES, SURFACE MOUNTED PAPER TOWEL DISPENSER, TYPE 304 STAINLESS STEEL, ALL WELDED CONSTRUCTION, ONE PIECE DOOR W/CONT. PIANO HINGE. TUMBLER LOCK, 400 C-FOLD OR 525 MULTIFOLD PAPER TOWELS— 3 1/8" TO 3 13/16" DEEP. (B-4262) DISPENSING LOCATION TO BE MOUNTED AT 42" A.F.F.
SD	SOAP DISPENSER	—	—	—	—	BOBRICK	MATRIX SERIES SOAP DISPENSER FOR ANTIBACTERIAL SOAPS, HIGH IMPACT ABS PUSH BUTTON, VANDAL RESISTANT LID, CONCEALED LOCKING DEVICE, ADA COMPLIANT, 50 OZ CAPACITY. (B-5050) DISPENSING LOCATION TO BE MOUNTED AT 48" A.F.F.
TP	TOILET TISSUE DISPENSER	—	—	—	—	BOBRICK	DOUBLE-ROLL TOILET TISSUE DISPENSER (B-2740), HEAVY DUTY CAST ALUMINUM BRACKET W/ SATIN FINISH, THEFT-RESISTANT SPINDLES SHALL BE MOLDED HIGH-IMPACT ABS WITH RETRACTABLE PINS AND CONCEALED LOCKING MECHANISMS, UNIT SHALL ACCOMMODATE TWO STANDARD-CORE TOILET TISSUE ROLLS UP TO 6" DIA. FOR SOLID CORE PARTITIONS PROVIDE SHEET-METAL SCREWS OR THROUGH-BOLTS, NUTS AND WASHERS, FOR HOLLOW-CORE PARTITIONS PROVIDE SOLID BACKING INTO WHICH SHEET-METAL SCREWS CAN BE SECURED, FOR BACK-TO-BACK INSTALLATION PROVIDE THREADED SLEEVES AND MACHINE SCREWS FOR FULL THICKNESS OF PARTITION, FOR MASONRY WALLS PROVIDE FIBER PLUGS OR EXPANSION SHIELDS AND SHEET-METAL SCREWS OR PROVIDE 1/8" TOGGLE BOLTS OR EXPANSION BOLTS.
G.B.	GRAB BARS	—	—	—	—	BOBRICK	18 GA. TYPE 304 STAINLESS STEEL, 1 1/2" OUTSIDE DIAMETER, 1 1/2" CLEARANCE TO WALL, CONCEALED MOUNTING FLANGES, SATIN FINISH WITH PEENED GRIPPING SURFACE, FLANGE COVERS FOR HIDDEN FASTENERS, LENGTHS AS NEEDED, ADA COMPLIANT MOUNTING (B6806.99)
MI	MIRROR	—	—	—	—	BOBRICK	STAINLESS STEEL, ONE-PIECE TYPE 430 CHANNEL FRAME, ALL EXPOSED SURFACES SHALL HAVE BRIGHT POLISHED FINISH, INTEGRAL HORIZONTAL HANGING BRACKETS FOR CONCEALED WALL HANGERS. CONCEALED LOCKING SCREWS, NO.1 QUALITY, 1/4" SELECT FLOAT GLASS, 15 YR GUARANTEE ON SILVER. THE BACK SHALL BE PROTECTED BY FULL-SIZE SHOCK-ABSORBING WATER-RESISTANT NONABRASIVE POLYETHYLENE PADDING, 36" HEIGHT, 24" WIDTH MIN. OR MATCH WIDTH OF VANITY. (B-165) TILT FORWARD WHERE NOTED FOR ADA COMPLIANCE.
PAR-1	TOILET PARTITIONS	—	—	—	—	GENERAL PARTITIONS	HIGH DENSITY POLYMER PANELS AND DOORS, UNIFORM COLOR THROUGHOUT, GRAFFITI RESISTANT, FLOOR SUPPORTED. STAINLESS STEEL HARDWARE, CONCEALED LATCH, COAT HOOK, SELF-CLOSING HINGE BRACKETS, COMBINATION LATCH KEEPER AND DOORSTOP WITH RUBBER BUMPER. STANDARD COLOR AS SELECTED BY OWNER.
HB	WALL HYDRANT	—	—	—	3/4"	ZURN	ECOLOTROL WALL HYDRANT (Z-1321), ANTI-SIPHON AUTOMATIC DRAINING, NON FREEZE, INTEGRAL BACK FLOW PREVENTER, COPPER CASTING, ALL BRONZE INTERIOR PARTS, 1/2 TURN CERAMIC DISC CARTRIDGE AND COMBINATION 3/4" FEMALE SOLDER AND 3/4" MALE PIPE THREAD INLET. STAINLESS STEEL FACE W/OPERATING KEY
TS	TRAP SEAL	—	—	—	—	JAY R. SMITH MFG. CO.	QUAD CLOSE TRAP SEAL — BARRIER TO PREVENT OR MINIMIZE EVAPORATION OF TRAP SEAL. SEALS WHEN CLOSED, OPENS WITH FLOW TO ALLOW DRAINAGE INSTALL WITHIN FLOOR DRAIN. ASSE 1072 COMPLIANT

PIPE THRU CONCRETE/MASONRY (ABOVE GRADE)

PIPE THRU CONCRETE/MASONRY (ABOVE GRADE)

PIPE THRU CONCRETE/MASONRY (BELOW GRADE)

PIPE THRU CONCRETE/MASONRY (BELOW GRADE)

INSULATED PIPE THRU WALL

INSULATED PIPE THRU WALL

UN-INSULATED PIPE THRU FIRE WALL

UN-INSULATED PIPE THRU FIRE WALL

UN-INSULATED THRU STANDARD WALL

UN-INSULATED THRU STANDARD WALL

PIPE PENETRATION DETAILS

SCALE: N.T.S.

WALL CLEANOUT DETAIL

WALL CLEANOUT DETAIL

SCALE: N.T.S.

STANDARD WATER METER

STANDARD WATER METER

SCALE: N.T.S.

NOTE

THE LOCATION AND ELEVATION OF EXISTING UNDERGROUND UTILITIES AS SHOWN ON THESE DRAWINGS ARE ONLY APPROXIMATE. NO GUARANTEE IS EITHER EXPRESSED OR IMPLIED AS TO THE COMPLETENESS OR ACCURACY THEREOF. THE CONTRACTOR SHALL BE EXCLUSIVELY RESPONSIBLE FOR DETERMINING THE EXACT LOCATION AND ELEVATION OF EXISTING UTILITIES AND PROPOSED UTILITY CROSSINGS IN THE FIELD PRIOR TO CONSTRUCTION. THE CONTRACTOR SHALL NOTIFY THE ENGINEER IF ANY CONFLICTS ARE APPARENT OR IF THE LOCATION OR DEPTH DIFFERS SIGNIFICANTLY FROM THE PLANS.

NOTE: DO NOT SCALE DRAWING, USE PRINTED DIMENSIONS ONLY. IF DRAWING IS REPRODUCED IN A SIZE OTHER THAN 24" x 36", SCALE MAY DIFFER. THIS DRAWING SHALL NOT BE DUPLICATED, MODIFIED, TRANSFERRED OR ISSUED WITHOUT THE WRITTEN CONSENT OF DAVID ARTHUR CONSULTANTS, INC. — COPYRIGHT 2025.

DAVID ARTHUR CONSULTANTS, INC.

110 MAIN STREET DUNDEE MI 48131
PHONE: (734) 823-5080

FOR BID PURPOSES ONLY

NOT FOR CONSTRUCTION OR APPROVAL

DUNDEE CIVIC COMMUNITY CENTER

165 VAN NEST STREET
DUNDEE, MICHIGAN 48131
VILLAGE OF DUNDEE, MONROE COUNTY

PLUMBING SCHEDULE & DETAILS

DEVELOPER/OWNER:

VILLAGE OF DUNDEE
MICHAEL HOPFMEISTER, VILLAGE MANAGER
350 WEST MONROE ST.
DUNDEE, MI 48131
(734) 529-3430

ISSUE

ITEM	DATE	BY
FOR BID ONLY	11/17/25	KI

SCALE*

AS NOTED

PLOT DATE


12/13/25

JOB NO.

306001

SHEET NO.

P1.01

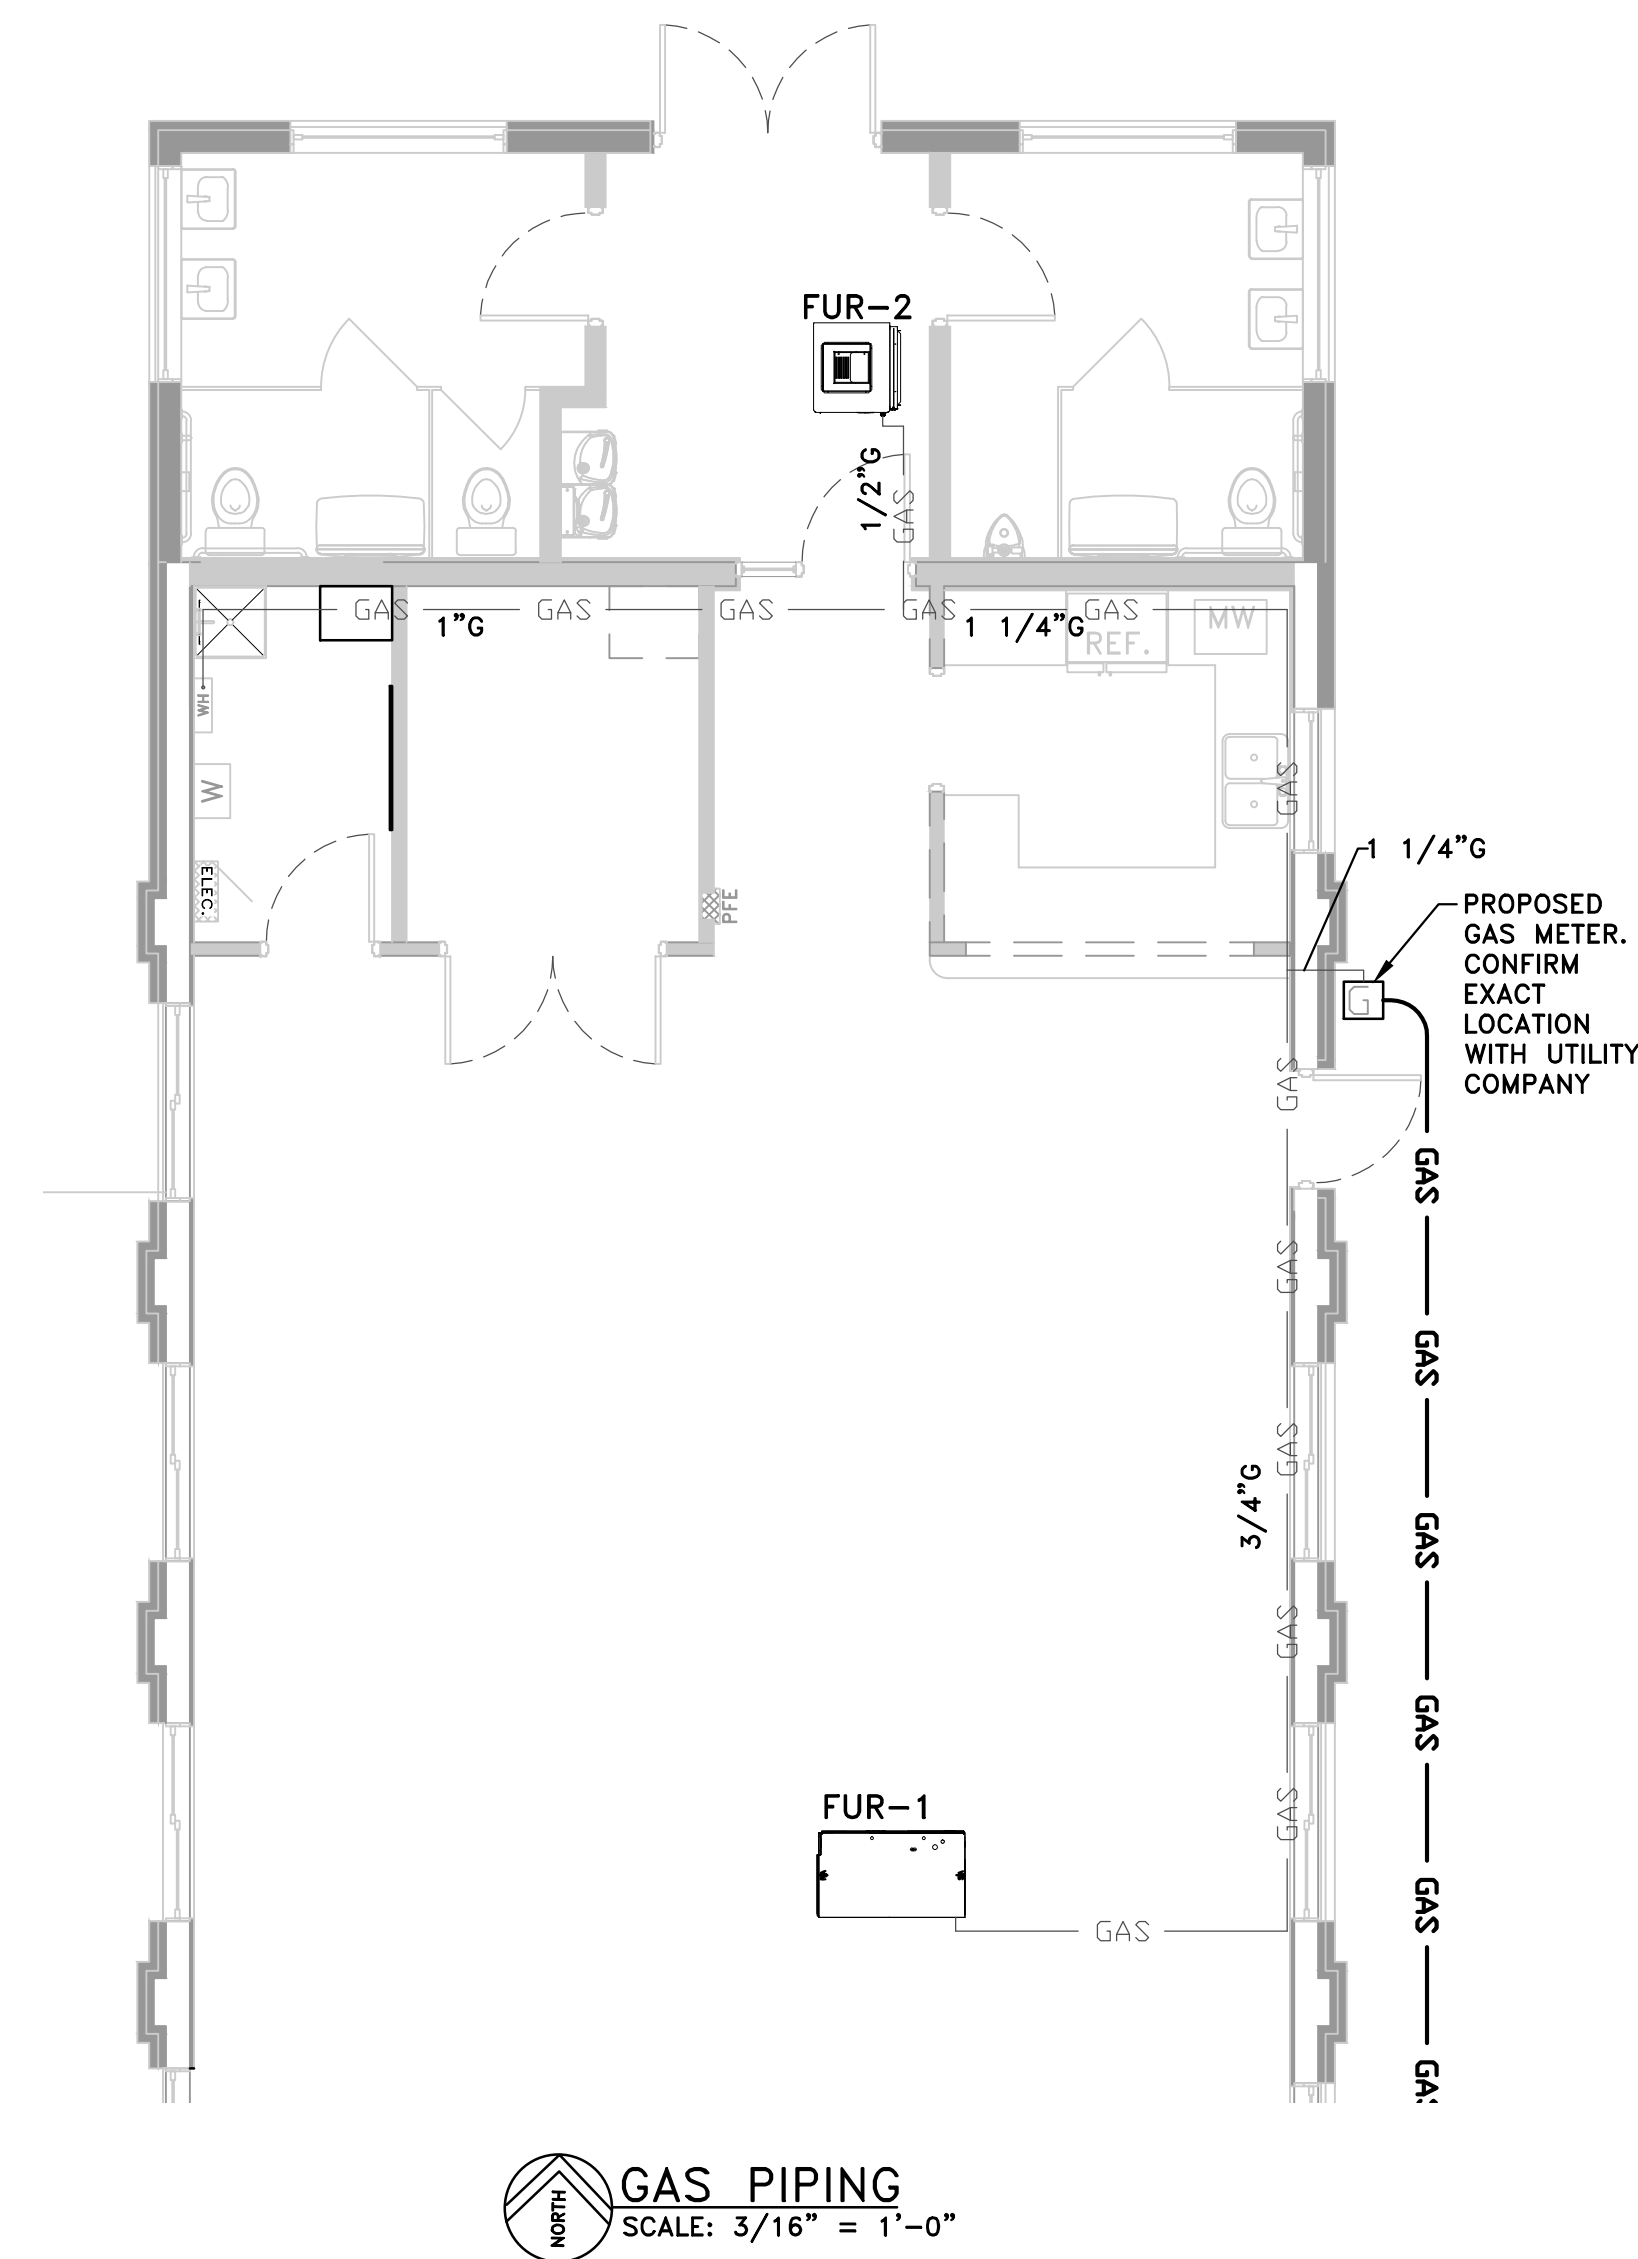


SCALE*	AS NOTED
PLOT DATE	12/10/25
JOB NO.	306001
SHEET NO.	M2.00

CONDUIT THROUGH EXTERIOR WALL


18. POWER DISTRIBUTION EQUIPMENT SUPPLIER SHALL PROVIDE EQUIPMENT APPROPRIATELY RATED AND BRACED TO ACCOMMODATE THE AVAILABLE FAULT CURRENT AT THE UTILITY COMPANY TRANSFORMER SECONDARIES. THE SUPPLIER SHALL ACCORDINGLY PROVIDE ANY RELATED CALCULATIONS SO THAT THEIR EQUIPMENT IS PROPERLY COORDINATED FOR THE AVAILABLE FAULT CURRENT. THE ELECTRICAL CONTRACTOR SHALL PROVIDE THE SUPPLIER WITH COPIES OF THE ELECTRICAL DOCUMENTS AS REQUIRED SO THAT PROPERLY RATED/BRACED EQUIPMENT IS PROVIDED UNDER THE BASE BID.
19. ALL WORKING CLEARANCES ARE TO BE PROVIDED, AND MAINTAINED WHERE WORKING WITH EXISTING CONDITIONS, AT ALL ELECTRICAL EQUIPMENT IN ACCORDANCE WITH N.E.C. AND GOVERNING CODES. A MINIMUM OF 3'-0" CLEARANCE TO BE PROVIDED AT ALL ELECTRICAL PANELS.
20. THE PLANS SHOWN ARE DIAGRAMMATIC ONLY AND DO NOT INTEND TO SHOW EVERY DETAIL OF THE ELECTRICAL DESIGN. THE ELECTRICAL CONTRACTOR SHALL BE RESPONSIBLE FOR ENSURING COMPLIANCE WITH ALL N.E.C. REQUIREMENTS. THIS INCLUDES NOT ONLY EQUIPMENT SHOWN ON THE PLANS, BUT ALSO EQUIPMENT AND DEVICES SHOWN IN THE RISER DIAGRAM AND ANY OTHER EQUIPMENT NECESSARY PER MANUFACTURERS REQUIREMENTS OR AS NEEDED FOR A COMPLETE OPERATIONAL SYSTEM.
21. COORDINATE ALL EXTERIOR WORK WITH AFFECTED UTILITIES AND THE OWNER. PROVIDE THE EXCAVATION, BACKFILL, COMPACTION AND TESTING NECESSARY TO INSTALL THE UNDERGROUND RACEWAYS SHOWN ON THE PLANS AS REQUIRED. REPAIR ALL LAWNS, LANDSCAPE, PLANTINGS AND OTHER EXTERIOR FINISHES TO MATCH THE ADJACENT AREAS AT THE TIME OF COMPLETION OF THE PROJECT. BACKFILL AND COMPACT TRENCHES TO GRADE FOR FINAL GRADING/FINISH BY OTHER TRADES.
22. LOW VOLTAGE CONTROL WIRING FOR MECHANICAL EQUIPMENT SHALL BE THE RESPONSIBILITY OF THE MECHANICAL CONTRACTOR.
23. PROVIDE ALL TEMPORARY LIGHTING REQUIRED THROUGHOUT THE PROJECT. REMOVE ANY TEMPORARY LIGHTING ONCE PERMANENT FIXTURES ARE OPERATIONAL. MAINTAIN LAMPS IN ALL FIXTURES, TEMPORARY AND PERMANENT, THROUGHOUT THE PROJECT.
24. ELECTRICAL CONTRACTOR TO RUN POWER TO ALL OVERHEAD DOOR OPENERS AND DOOR OPERATORS, ALL PROPOSED EQUIPMENT IN ACCORDANCE WITH MANUFACTURERS CONNECTION REQUIREMENTS.
25. FOR EACH PIECE OF EQUIPMENT, IF NO COLOR CODING SYSTEM EXISTS FOR IDENTIFYING SYSTEM FUNCTION AND VOLTAGE, COLOR CODE CIRCUITS AS FOLLOWS:
THREE PHASE POWER 208/120 VOLTS:
PHASE X(A): BLACK
PHASE Y(B): RED
PHASE Z(C): BLUE
NEUTRAL: WHITE
GROUND: GREEN
PROVIDE A NAMETAG ON EACH IDENTIFYING THE PANEL AND CIRCUIT NUMBER FEEDING THE EQUIPMENT. NAMETAGS SHALL CONSIST OF BLACK TEXT PERMANENTLY LAMINATED TO ADHESIVE BACKED CLEAR NYLON OR MYLAR TAPE. MARK JUNCTION BOX COVERS USING A "SHARPIE" TYPE PERMANENT MARKER WITH THE PANEL AND BREAKER NUMBERS OF THE CIRCUITS.

SYMBOL	TYPE	MANUFACTURER*	DESCRIPTION	
	EF	GREENHECK	EXHAUST FAN, SEE MECHANICAL DRAWING FOR SPECIFICATIONS, U.L. LISTED W/GFCI CONNECTION, PRE-WIRED OUTLET BOX, INTERCONNECT TO ROOM OCCUPANCY SENSOR.	120/1/60
	-	-	NEW LIGHTING/POWER DISTRIBUTION PANEL, 120/208V, THREE PHASE, (GE, WESTINGHOUSE, ITE, SQUARE D, OR EQUAL), PROVIDE CIRCUIT BREAKERS PER PANEL SCHEDULE & WIRING FOR EACH PER NEC LABEL. LABEL ALL PANEL SCHEDULES ON DOOR. VERIFY WHERE UNDERGROUND POWER SERVICE IS COMING INTO THE BUILDING AND COORDINATE WITH UTILITY.	120/208/3/60
	-	LEVITON	DUPLEX CONVENIENCE OUTLET, 20 A., 2 POLE, WITH GROUND (NEMA 5-20R) COLOR WHITE OR AS SELECTED BY OWNER. PLASTIC COVER PLATE. M.H. AT 18" TO BOTTOM OF BOX UNLESS NOTED OTHERWISE.	120
	-	LEVITON	DUPLEX OUTLET AS SPECIFIED ABOVE W/ GROUND FAULT CIRCUIT INTERRUPTOR	120
	-	-	DUPLEX OUTLET AS SPECIFIED ABOVE, MOUNTED AT A SPECIFIC HEIGHT ABOVE FINISH FLOOR (AFF) TO THE CENTERLINE OF ELECTRICAL BOX.	-
	-	LEVITON	GFCI DUPLEX OUTLET AS SPECIFIED ABOVE WITH WEATHER RESISTANT COVER WITH CORDS PLUGGED IN	-
	-	LEVITON	FOUR-IN-ONE OUTLET, 20A 120V, 2 POLE, WITH GROUND. METAL BOX FOR RECESSED IN CONCRETE FLOORS, PLASTIC WEATHERPROOF COVER PLATE WITH REMOVABLE CAPS FOR EACH OUTLET. COLOR TO MATCH CARPETING. COORDINATE WITH OWNER. COLOR WHITE OR AS SELECTED BY OWNER.	-
	-	-	MOTOR EQUIPMENT ITEM (HVAC FAN, ETC.) - SIZE, PHASE, VOLTAGE, & FUNCTION AS SO NOTED. REFER ALSO TO ELECTRICAL NOTES AND PANEL SCHEDULES. PROVIDE DISCONNECT SWITCH OR GFI OUTLET AS REQUIRED BY OWNER.	AS NOTED
	-	LEVITON	SINGLE-POLE QUIET SWITCH, 20 AMP, PLASTIC COVER PLATE, WHITE OR AS SELECTED BY OWNER. COLOR OF SWITCH AND COVER PLATE TO MATCH, U.N.O. 48" AFF MAX. TO CENTERLINE.	120
	-	LEVITON	THREE-WAY QUIET SWITCH, 20 AMP, PLASTIC COVER PLATE, WHITE OR AS SELECTED BY OWNER. COLOR OF SWITCH AND COVER PLATE TO MATCH, U.N.O. 48" AFF MAX. TO CENTERLINE.	120
	-	LEVITON	PRESET SLIDE DIMMER, SINGLE POLE, 120 VOLT, 20 AMP, WHITE OR IVORY, PLASTIC COVER PLATE OR AS SELECTED BY OWNER.	120
	-	LEVITON	NETWORK OUTLET. PROVIDE RECESSED BOX & 3/4" (U.N.O.) EMT OR PVC CONDUIT TO IT ROOM. EXACT TERMINATION POINT TO BE COORDINATE W/IT OWNER. CONCEAL ALL CONDUITS IN WALLS IN FINISH SPACES, UNLESS DIRECTED DIFFERENTLY BY OWNER. BOXES TO BE 18" TO GENERAL AREA U.N.O. ABOVE FINISH FLOOR. PROVIDE 1-CAT 6 CABLE FROM BOX TO TERMINATION POINT IN IT ROOM. COVER PLATE TO BE AS DIRECTED BY OWNER.	-
	-	-	SAFETY SWITCH, WP INDICATES NEMA 3P, FUSED, U.N.O. VERIFY SIZE WITH ATTACHED LOAD AND MANUFACTURER SPECIFICATIONS	-
	-	-	PHOTOCELL TO BE INTEGRAL TO THE FIXTURE WHERE NOTED AND TRIGGERED INDIVIDUALLY. EXTERNAL PHOTOCELL WHERE MULTIPLE FIXTURES TO BE CONNECTED. LOCATE REMOTE PHOTOCELL SENSOR IN THE GENERAL AREA OF THE FIXTURE, FACING NORTHEASTERLY IF POSSIBLE, ARROW INDICATES GENERAL DIRECTION PHOTOCELL SHOULD FACE. COORDINATE EXACT LOCATION OF REMOTE SENSOR WITH ARCHITECT PRIOR TO INSTALLATION.	-
	-	-	MECHANICAL TIMER, TO BE SET IN INDOOR METAL OR PLASTIC BOX, EASILY ACCESSIBLE. TIMER, OFF AND MANUAL OVERRIDE OPTIONS, TO BE LOCATED IN THE MECHANICAL ROOM #107.	-

NOTE: DO NOT SCALE DRAWING, USE PRINTED DIMENSIONS ONLY. IF DRAWING IS REPRODUCED IN A SIZE OTHER THAN 24" x 36", SCALE MAY DIFFER. THIS DRAWING SHALL NOT BE DUPLICATED, MODIFIED, TRANSFERRED OR ISSUED WITHOUT THE WRITTEN CONSENT OF DAVID ARTHUR CONSULTANTS, INC. - COPYRIGHT 2021

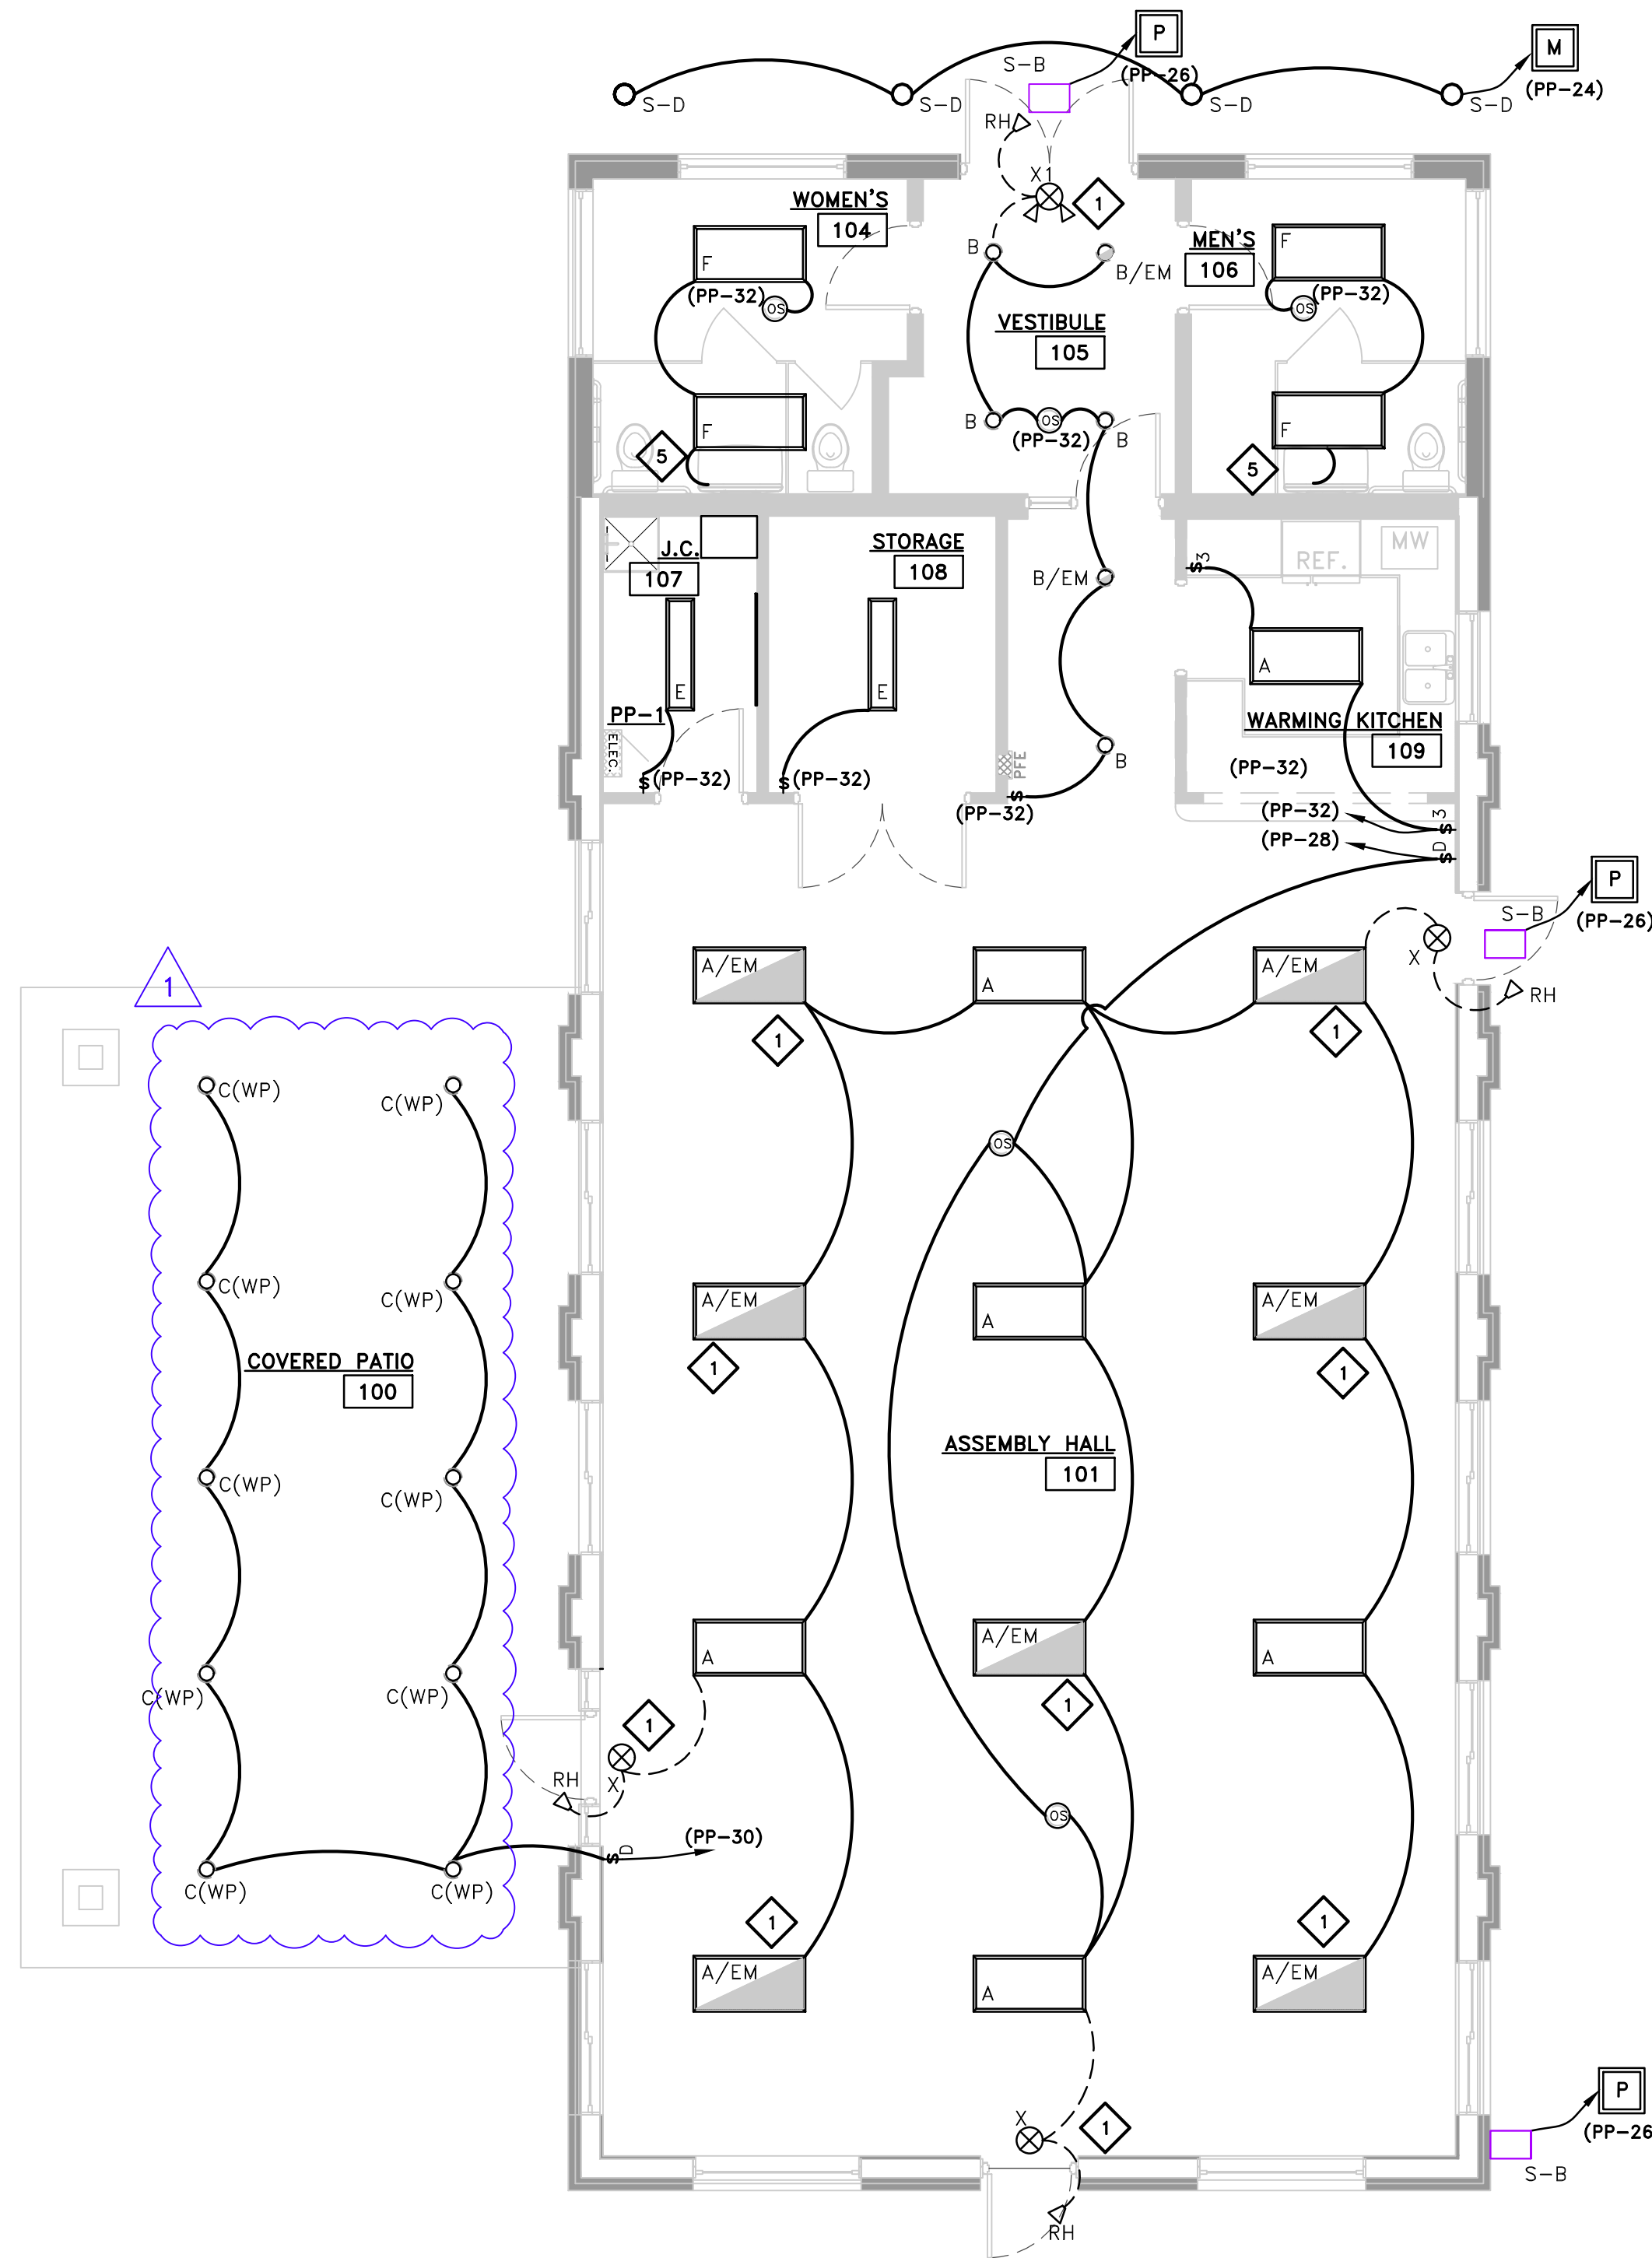

LIGHTING PLAN - MAIN FLOOR
SCALE: 3/16" = 1'-0"

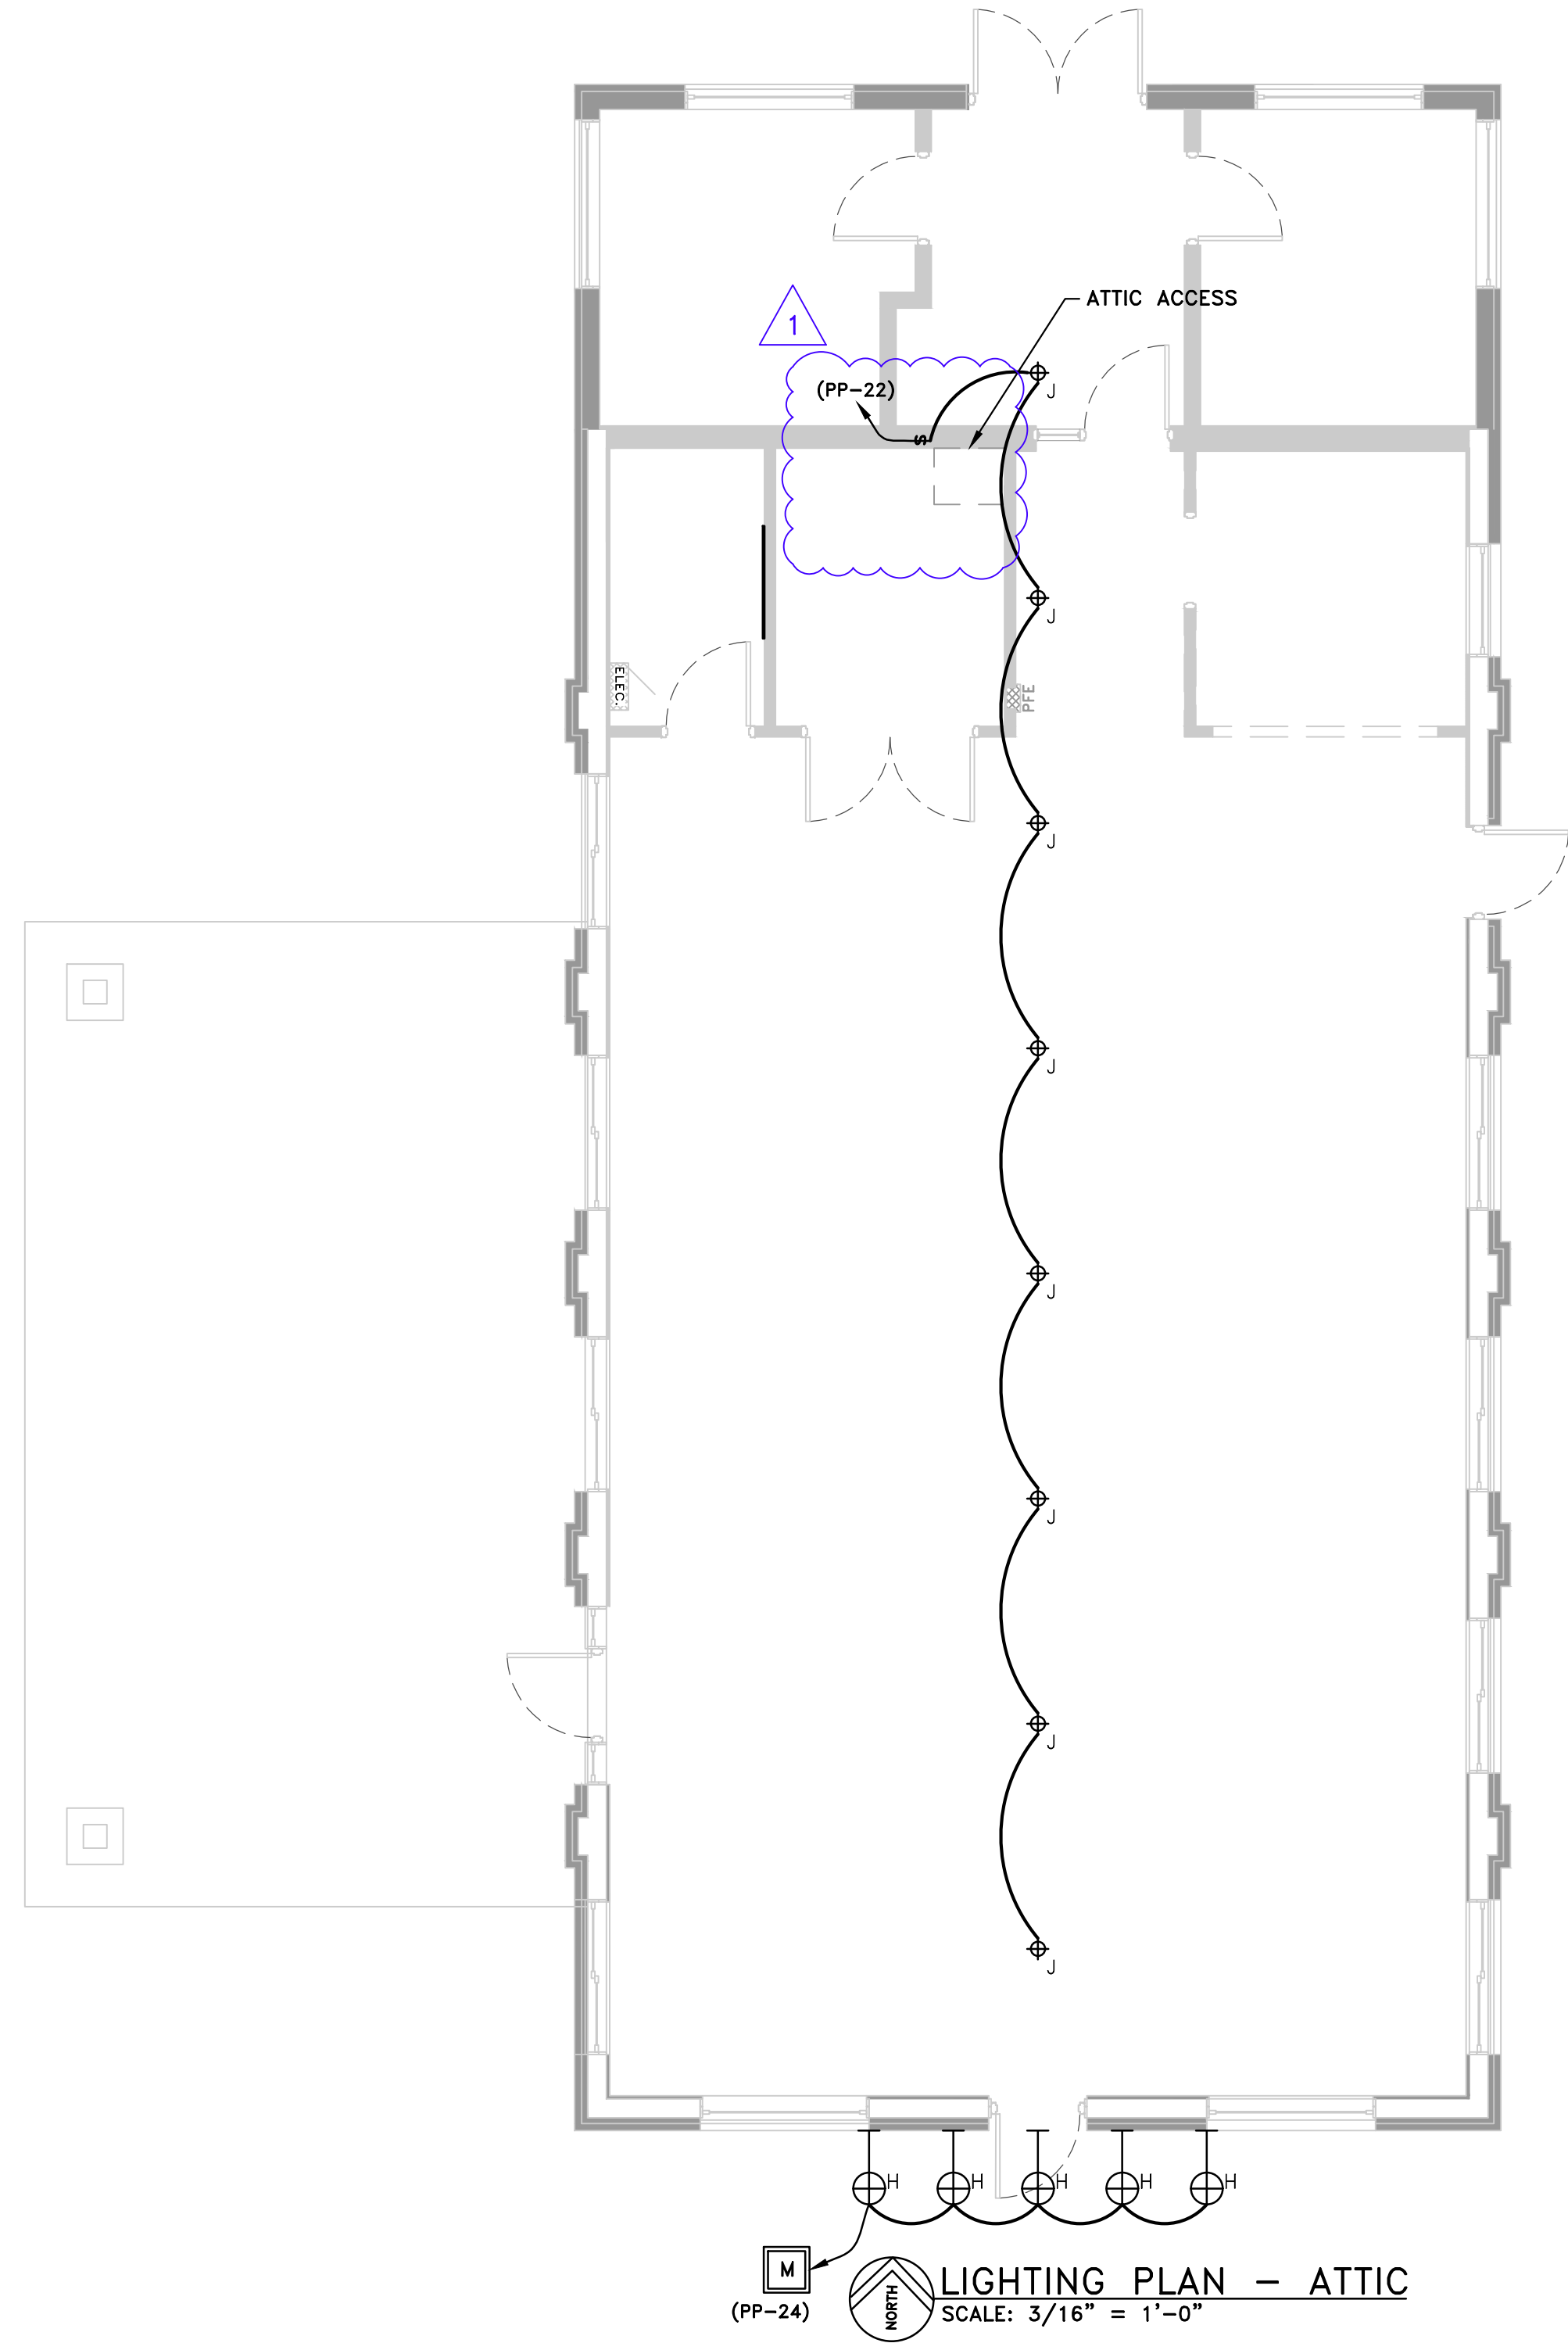

LIGHTING PLAN - ATTIC
SCALE: 3/16" = 1'-0"


- GENERAL NOTES:**
1. ALL WORK SHALL BE IN ACCORDANCE WITH THE 2017 VERSION OF THE NEC, AND WITH ALL INSTRUCTIONS PROVIDED BY THE AHJ.
 2. THE EC SHALL OBTAIN ALL PERMITS AND CERTIFICATIONS OF INSPECTION AS REQUIRED FOR THE BENEFICIAL USE OF THE BUILDING BY THE OWNER.
 3. PROVIDE DEDICATED (NON-SHARED) NEUTRAL CONDUCTORS FOR ALL RECEPTACLE CIRCUITS.
 4. IN GENERAL, ALL RECEPTACLES SHALL BE MOUNTED AT 18" TO CENTERLINE AFF, UNLESS NOTED OTHERWISE. COORDINATE THE EXACT MOUNTING HEIGHTS OF RECEPTACLES OVER COUNTER TOPS WITH THE ARCHITECTURAL TRADES.

- REFERENCED NOTES:**
1. CONNECT EMERGENCY FIXTURES TO THE HOT (NON-SWITCHED) SIDE OF THE LIGHTING CIRCUIT. TYPICAL ALL EM TYPE FIXTURES.
 2. PROVIDE MECHANICAL TIMERS - 3, INSTALL PER MANUFACTURERS REQUIREMENTS. HEIGHT TO BE 42" O.C. TO CENTERLINE
 3. (OMITTED).
 4. SEE GROUND BAR DETAIL, SHEET E4.00.
 5. FRACT HP EX FAN, BY MECH TRADES. INTERCONNECT TO ROOM OCCUPANCY SENSOR
 6. PROVIDE POWER TO TANKLESS WATER HEATER, CIRCUIT TO #27. COORDINATE EXACT CONNECTION WITH MANUFACTURER REQUIREMENTS.
 7. PROVIDE NETWORK AND RECEPTACLE 80" AFF FOR WINDOW MONITOR.
 8. TELEPHONE AND NETWORK TERMINATION BOARD, 4'x4'x3/4"




ISSUE	DATE	BY
FOR BID ONLY	11/17/25	KI
ADDENDUM No.2	12/10/25	KI
REVIEWED BY		
DATE		

SCALE*	AS NOTED
PLOT DATE	12/10/25
JOB NO.	306001
SHEET NO.	

 


- ### REFERENCE NOTES:
1. CONNECT EMERGENCY FIXTURES TO THE HOT (NON-SWITCHED) SIDE OF THE LIGHTING CIRCUIT. TYPICAL ALL EM TYPE FIXTURES.
 2. PROVIDE MECHANICAL TIMERS - 3, INSTALL PER MANUFACTURERS REQUIREMENTS. HEIGHT TO BE 42" O.C. TO CENTERLINE
 3. (OMITTED).
 4. SEE GROUND BAR DETAIL, SHEET E4.00.
 5. FRACT HP EX FAN, BY MECH TRADES. INTERCONNECT TO ROOM OCCUPANCY SENSOR
 6. PROVIDE POWER TO TANKLESS WATER HEATER, CIRCUIT TO #27. COORDINATE EXACT CONNECTION WITH MANUFACTURER REQUIREMENTS.
 7. PROVIDE NETWORK AND RECEPTACLE @ 80" AFF FOR WINDOW MONITOR.
 8. TELEPHONE AND NETWORK TERMINATION BOARD, 4'x4'x3/4"

 


NOTE: DO NOT SCALE DRAWING, USE PRINTED DIMENSIONS ONLY. IF DRAWING IS REPRODUCED IN A SIZE OTHER THAN 24" x 36", SCALE MAY DIFFER. THIS DRAWING SHALL NOT BE DUPLICATED, MODIFIED, TRANSFERRED OR ISSUED WITHOUT THE WRITTEN CONSENT OF DAVID ARTHUR CONSULTANTS, INC. - COPYRIGHT 2025

SCALE*	AS NOTED
PLOT DATE	12/10/25
JOB NO.	306001
SHEET NO.	
E3.00	

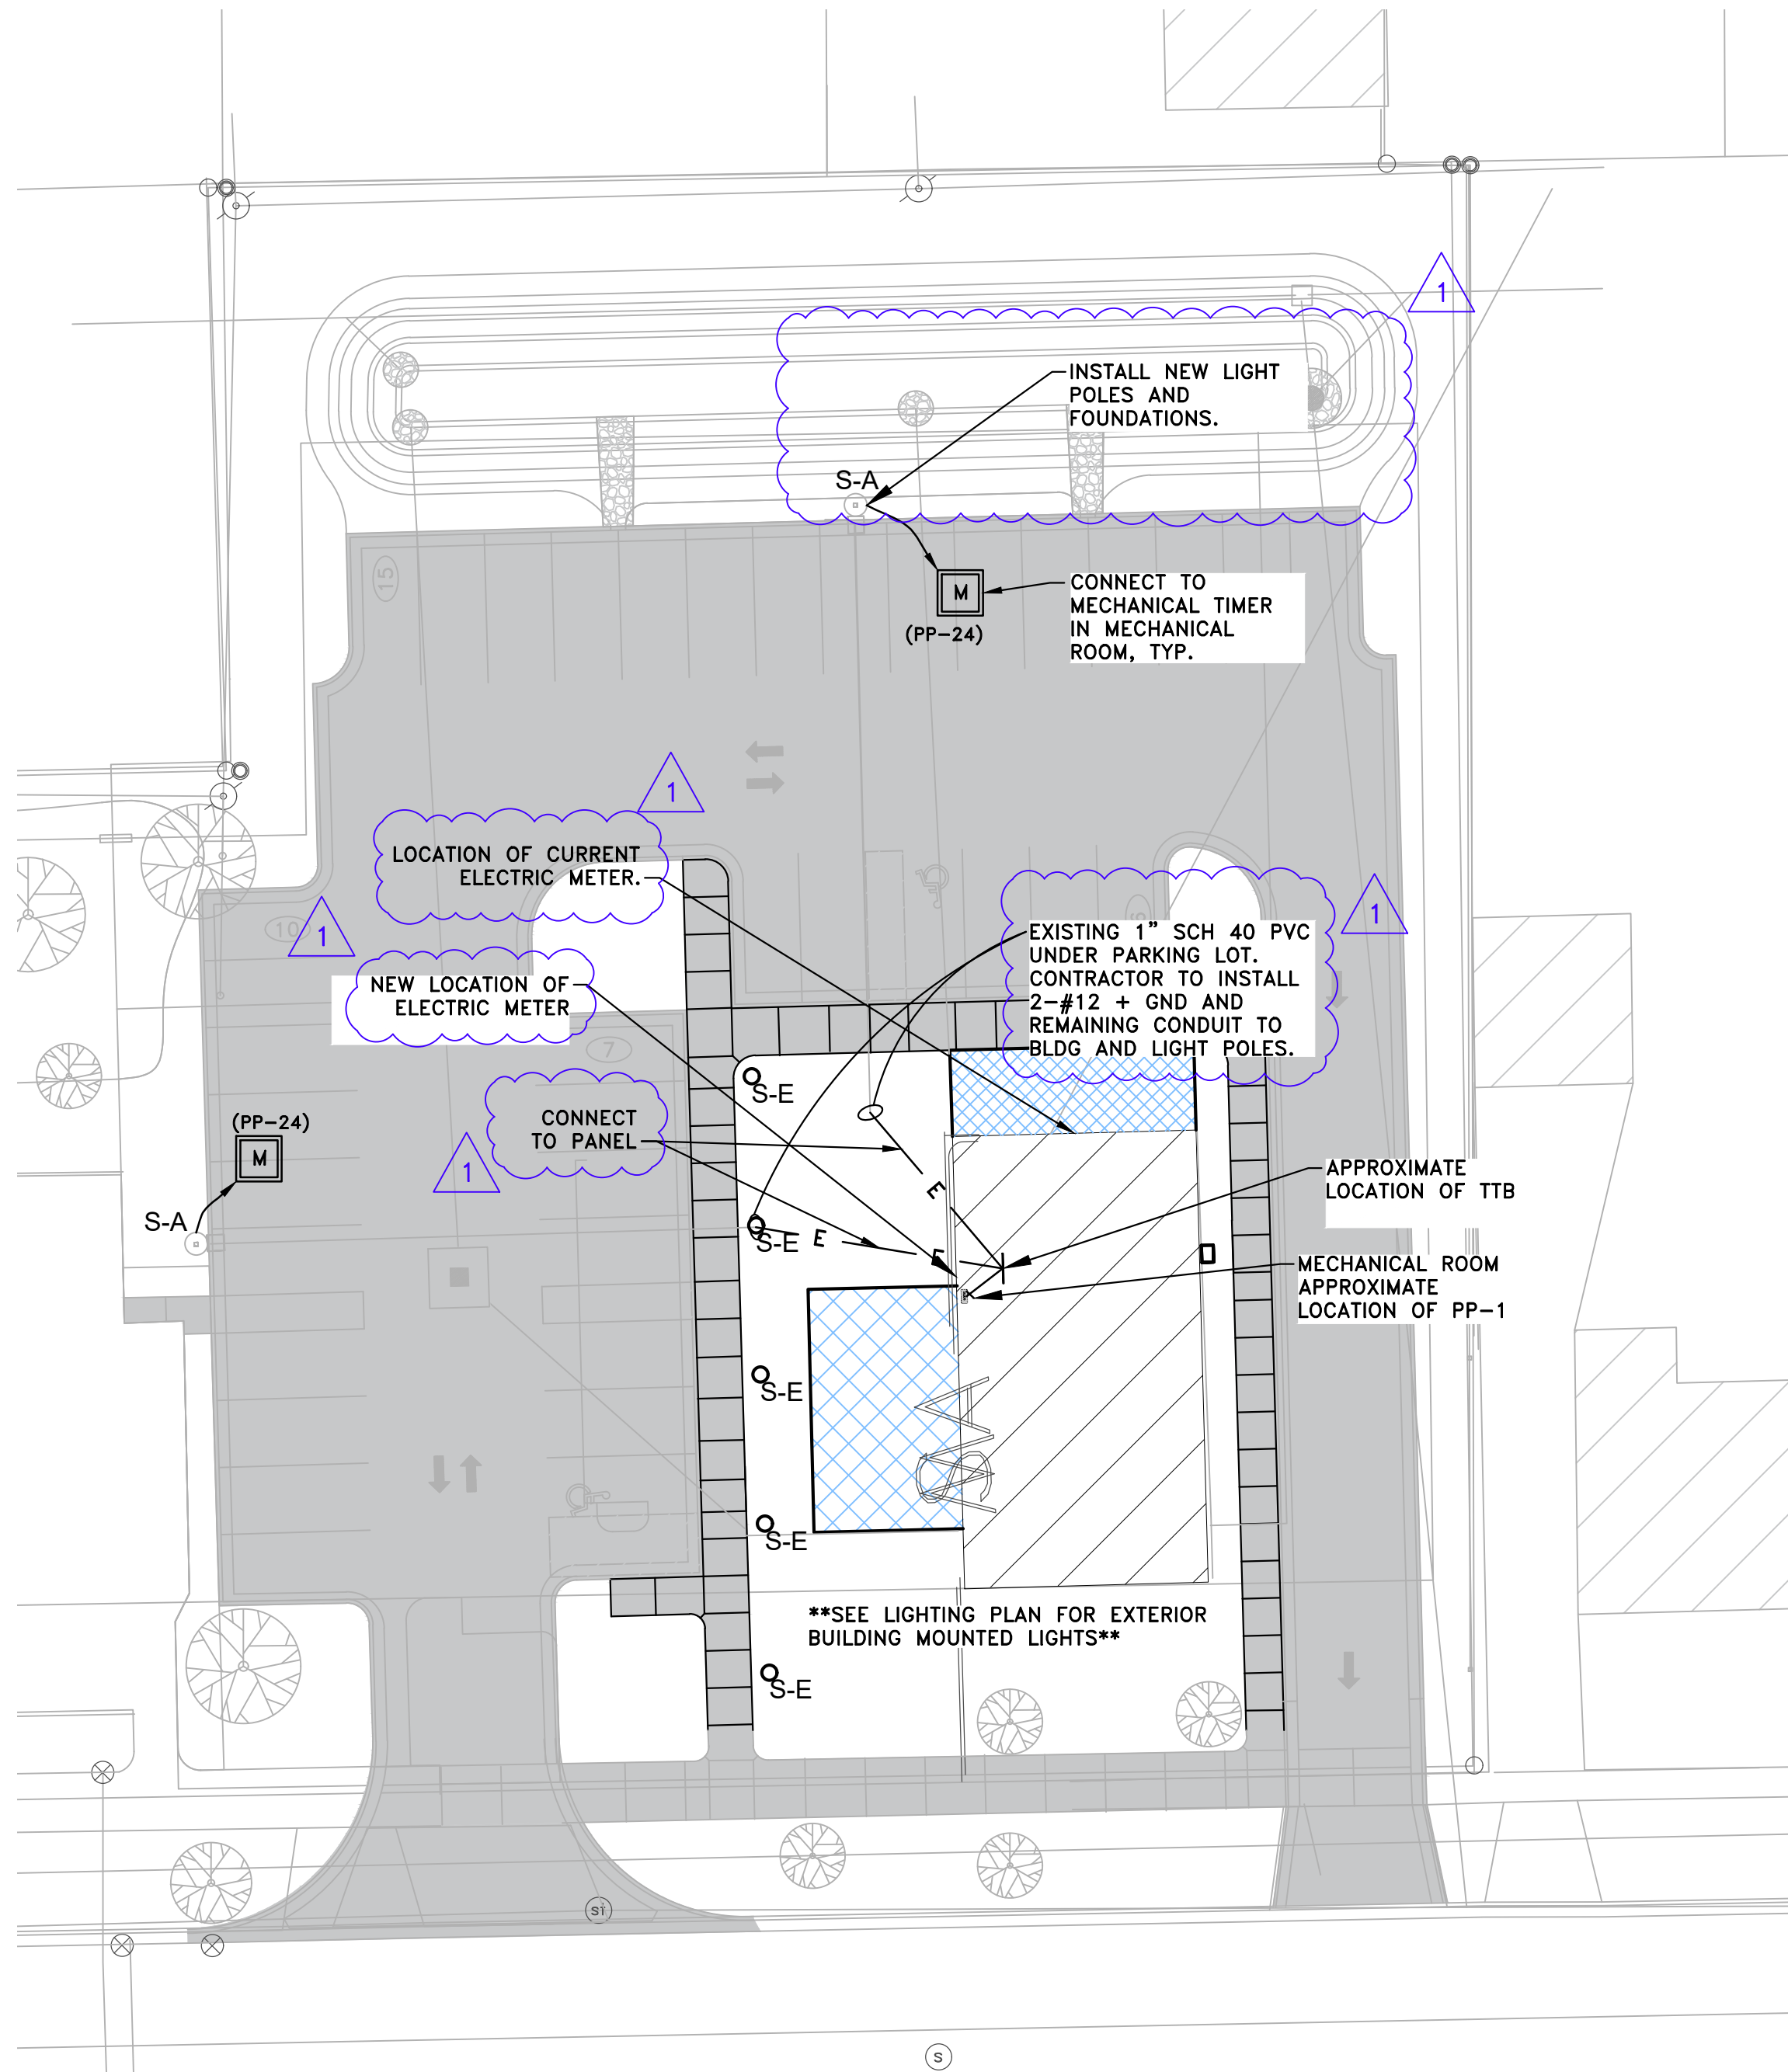


SITE ELECTRICAL
SCALE: 1" = 20'-0"

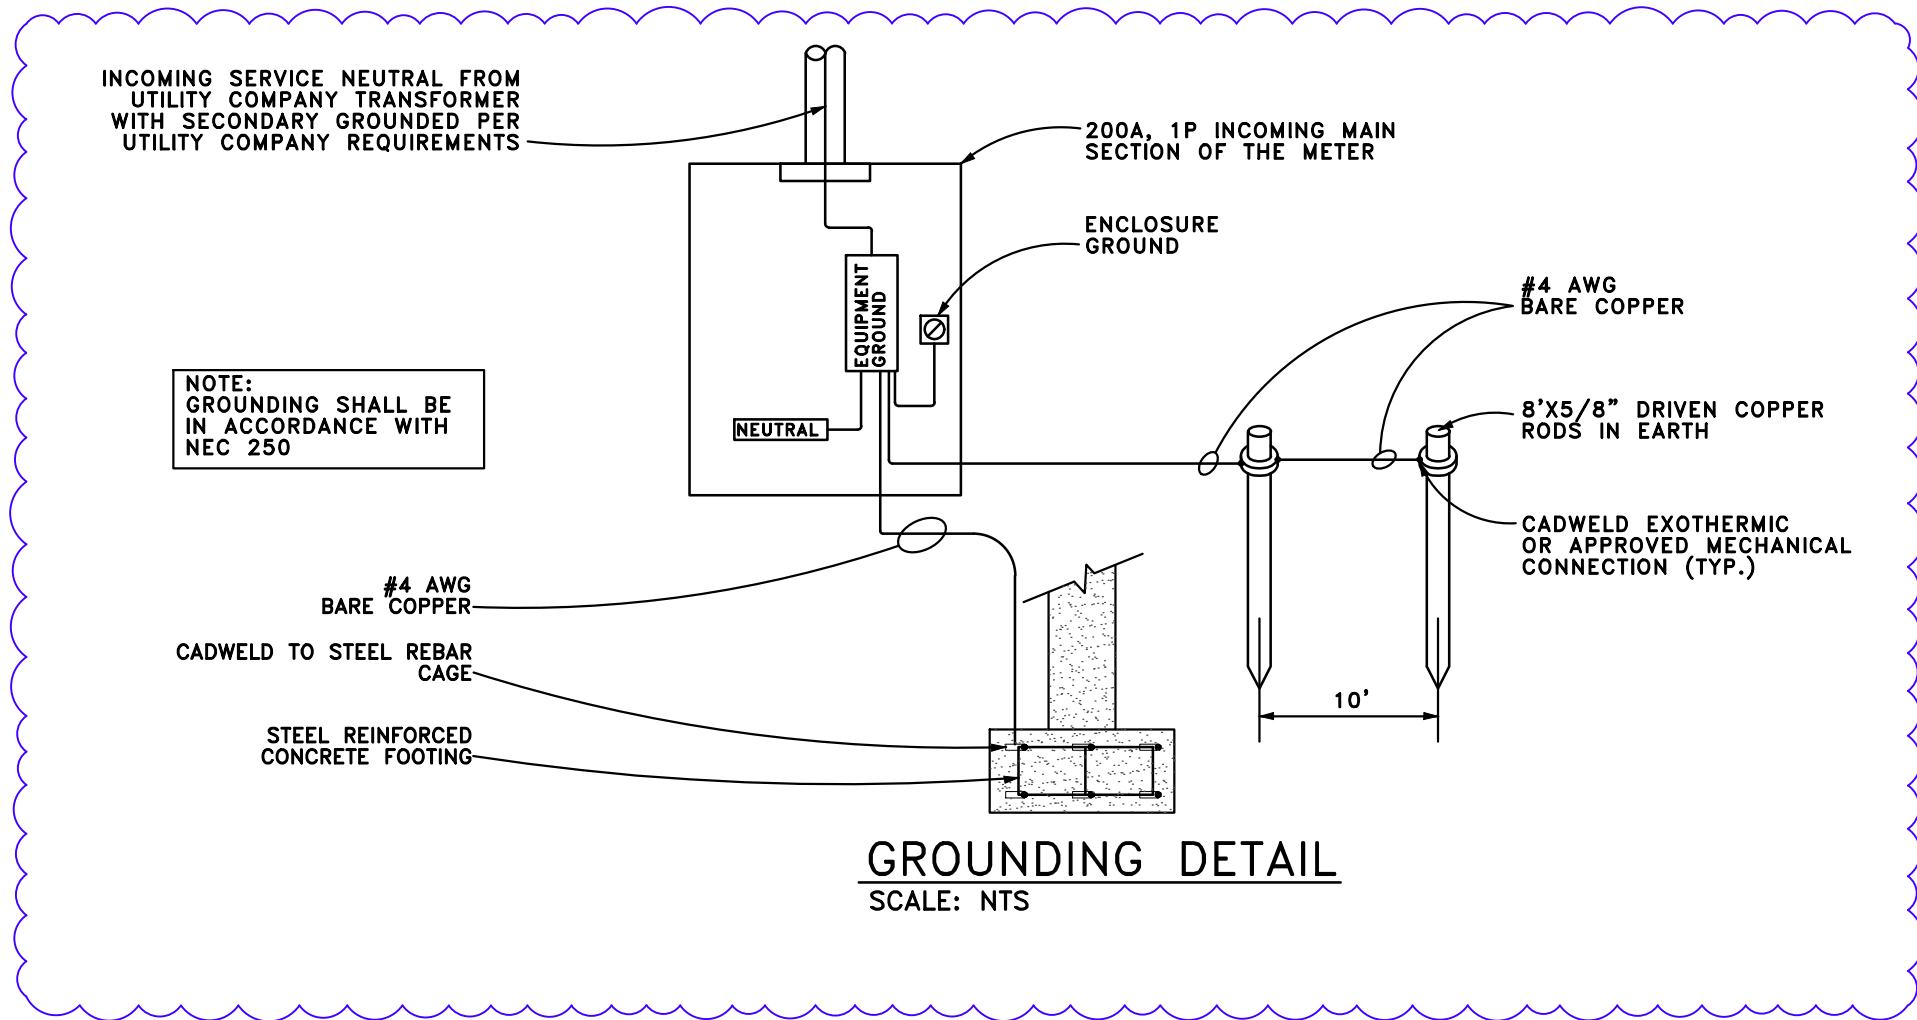


GROUNDING DETAIL
SCALE: NTS

Schedule								
Symbol	Label	QTY	Manufacturer	Catalog	Description	Number Lamps	Lamp Output	LLF
	S-A	2	Lithonia Lighting	DSX1 LED P5 35K 80CRI T4M HS	D-Series Size 1 Area Luminaire P5 Performance Package 3500K CCT 80 CRI Type 4 Medium HouseSide Shield	1	13846	1
		5						
	S-E		Lithonia Lighting	DSXB LED 12C 700 30K ASY	D-SERIES BOLLARD WITH 12 3000K LEDS OPERATED AT 700mA AND ASYMMETRIC DISTRIBUTION	1	2173	1
								31

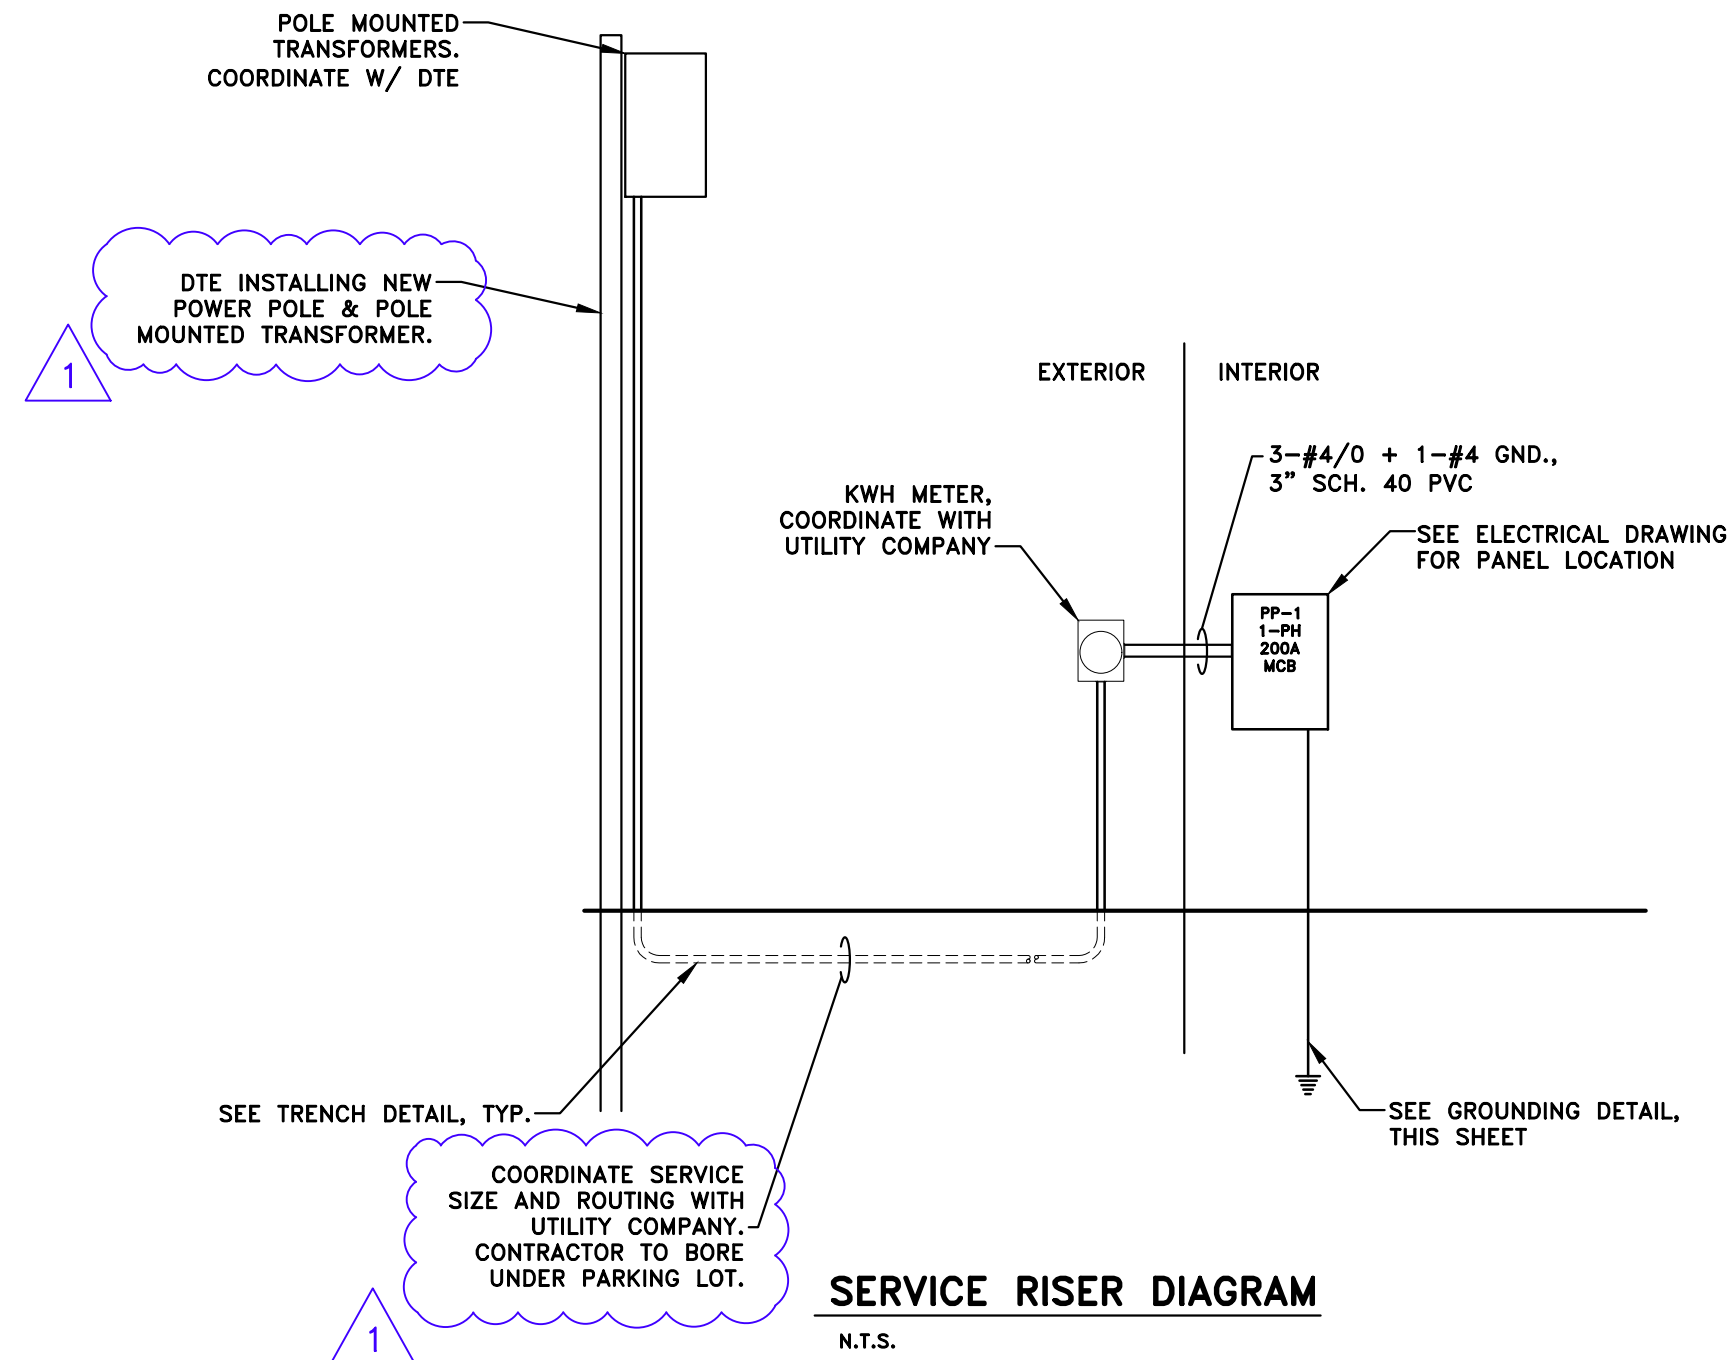

SERVICE RISER DIAGRAM
N.T.S.

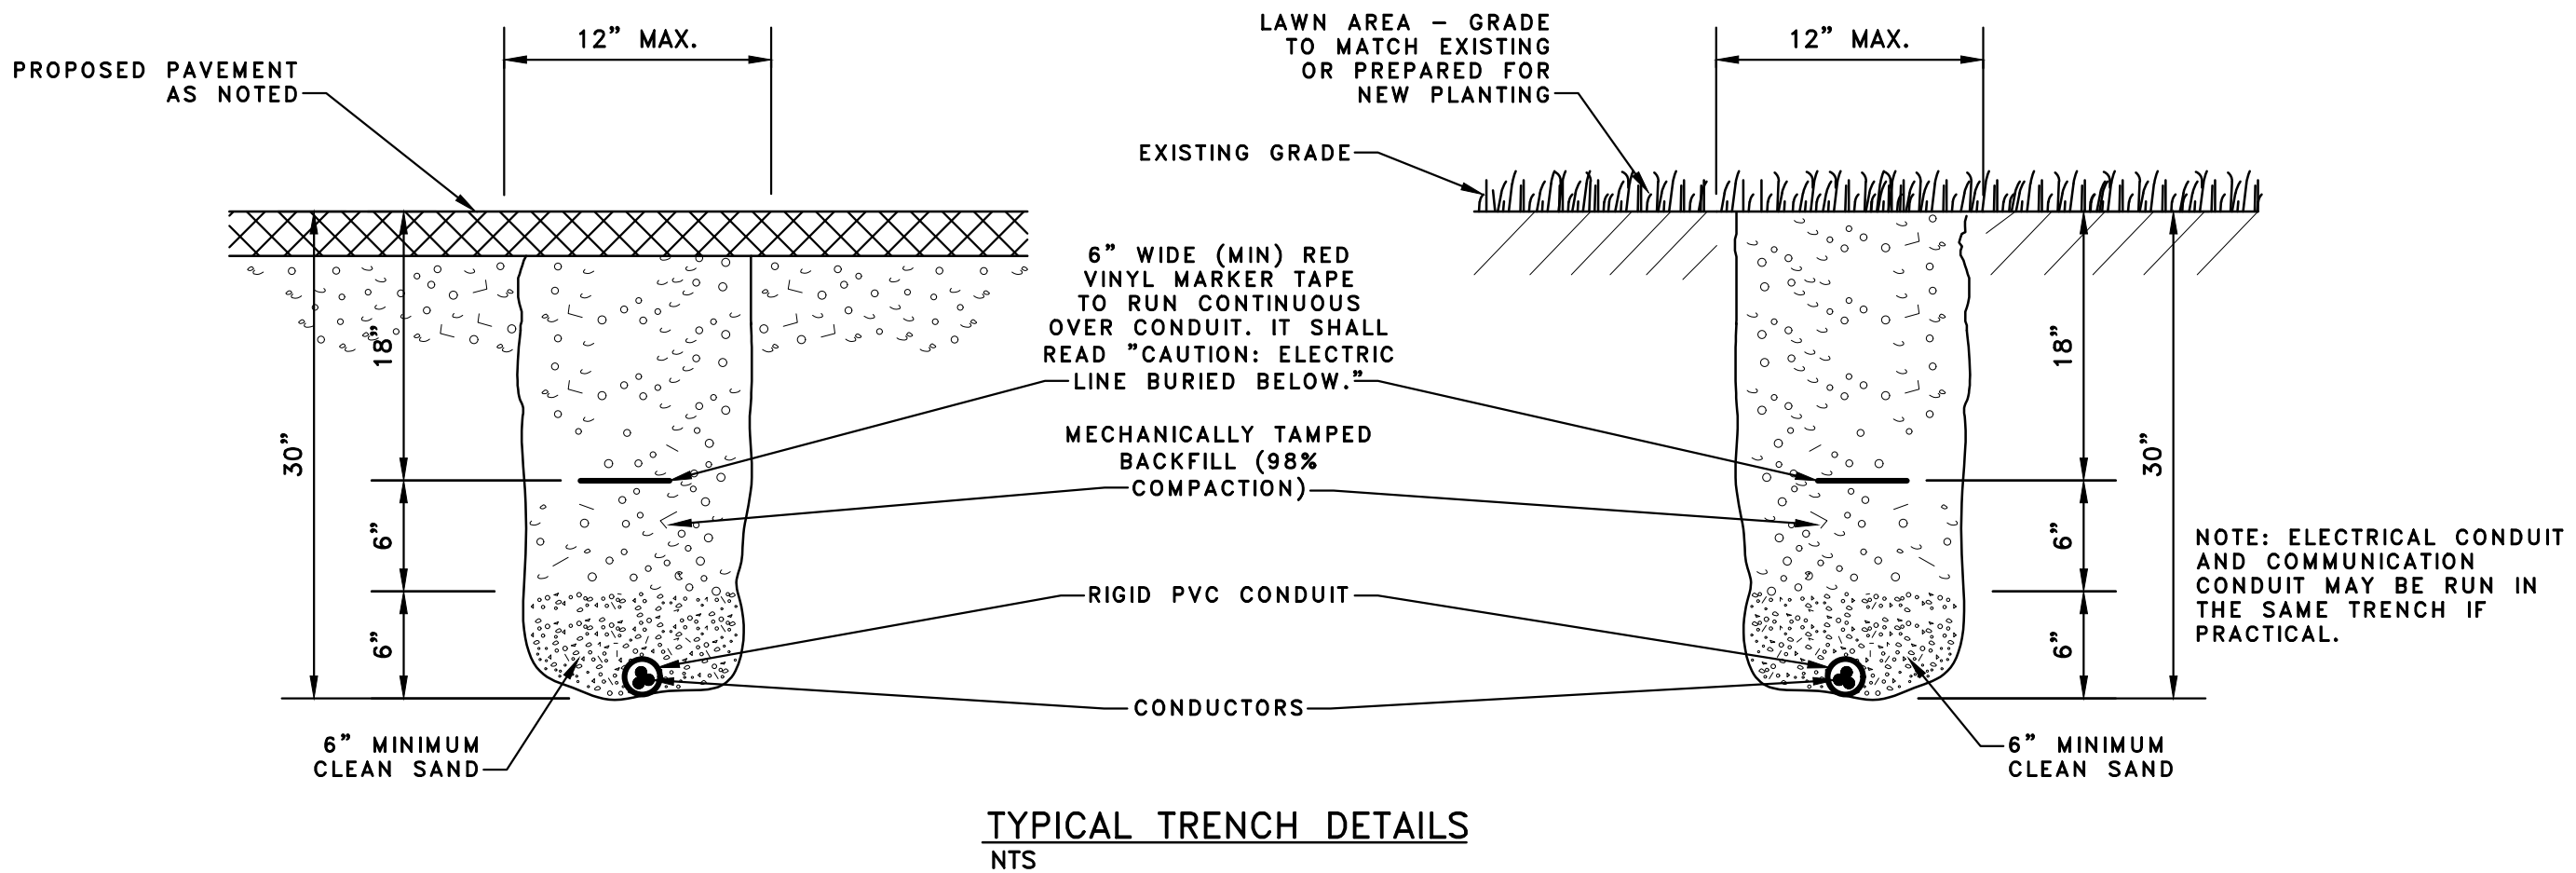

TYPICAL TRENCH DETAILS
NTS

NOTE
THE LOCATION AND ELEVATION OF EXISTING UNDERGROUND UTILITIES AS SHOWN ON THESE DRAWINGS ARE ONLY APPROXIMATE. NO GUARANTEE IS EITHER EXPRESSED OR IMPLIED AS TO THE COMPLETENESS OR ACCURACY THEREOF. THE CONTRACTOR SHALL BE EXCLUSIVELY RESPONSIBLE FOR DETERMINING THE EXACT LOCATION AND ELEVATION OF EXISTING UTILITIES AND PROPOSED UTILITY CROSSINGS IN THE FIELD PRIOR TO CONSTRUCTION. THE CONTRACTOR SHALL NOTIFY THE ENGINEER IF ANY CONFLICTS ARE APPARENT OR IF THE LOCATION OR DEPTH DIFFERS SIGNIFICANTLY FROM THE PLANS.



NOTE: DO NOT SCALE DRAWING, USE PRINTED DIMENSIONS ONLY. IF DRAWING IS REPRODUCED IN A SIZE OTHER THAN 24" x 36", SCALE MAY DIFFER. THIS DRAWING SHALL NOT BE DUPLICATED, MODIFIED, TRANSFERRED OR ISSUED WITHOUT THE WRITTEN CONSENT OF DAVID ARTHUR CONSULTANTS, INC. — COPYRIGHT 2025.

FOR BID PURPOSES ONLY
NOT FOR CONSTRUCTION OR APPROVAL

DUNDEE CIVIC COMMUNITY CENTER
165 VAN NEST STREET
DUNDEE, MICHIGAN 48131
VILLAGE OF DUNDEE, MONROE COUNTY

SITE ELECTRICAL & DETAILS

DEVELOPER/OWNER:
VILLAGE OF DUNDEE
MICHAEL HOFFMEISTER, VILLAGE MANAGER
350 WEST MONROE ST.
DUNDEE, MI 48131
(734) 529-3430

ISSUE	DATE	BY
FOR BID ONLY	12/17/25	KI
ADDENDUM No.2	12/10/25	KI

SCALE*	AS NOTED
PLOT DATE	12/15/25
JOB NO.	306001
SHEET NO.	

E4.00